



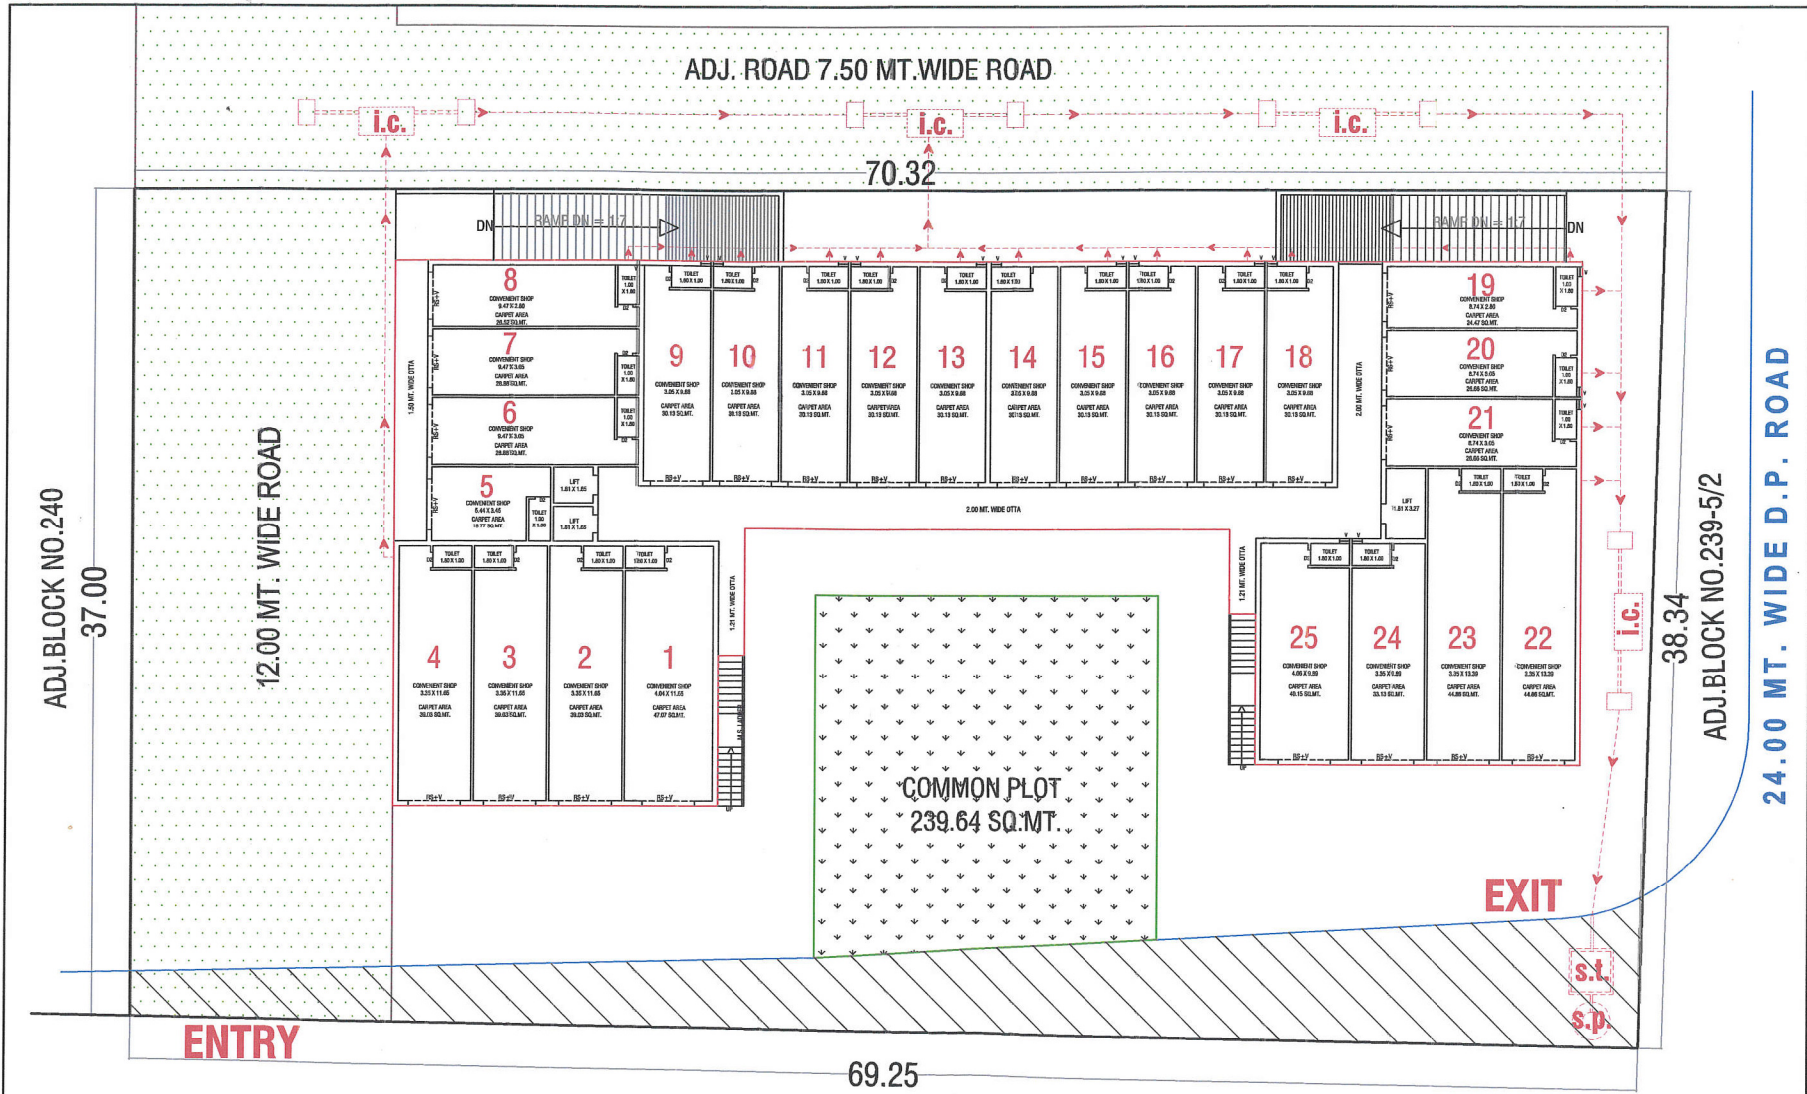

SVN CONSULTING ENGINEER

Proprietor
KAMLESHBHAI PATEL
M.E. (STR), M.I.E. (S)
Lic. No. BAUDA-L-STR-04/104
Lic. No. GPCPSIRDA/STR.DESIGNER/104

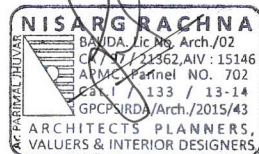

Harikrishna Enterprise

Proprietor

INSPECTION CHAMBER

SEPTIC TANK & SOAKPIT

JOB TITLE

DRAINAGE LAYOUT OF S.R. NO.239/5/1/1, SUB PLOT_1 FOR MR. KAMLESHBHAI PATEL AT BHARUCH.



JOB NO. 00.00	DRG. NO. > 00
DRG. TITLE	DRAINAGE LAYOUT PLAN
DATE	20-07-2019
DEALT	Info
CHECKED	
SCALE	N.T.S

NISARG RACHNA
ARCHITECTS, PLANNERS
VALUERS & INTERIOR DESIGNERS
17, HAZ, ROAD POLICE COMPLEX, JACOBANNA ROAD, BHARUCH
PHONE:- (0) 82342 248 897, (M) 98 254 33 189
Email:- nisarg_rachna@yahoo.com, info@nisargrachna.com