

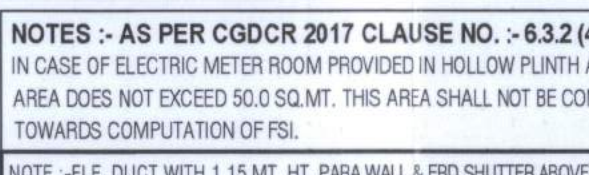
NOTES:
1. IT IS CERTIFIED THAT THE PLAN UNDER REFERENCE IS SUBMITTED BY ME AND THE DIMENSIONS OF ALL SIDS OF PLOT AND PLOT AREA AS SHOWN IN PLAN ARE MEASURED BY ENGINEER ON RECORD AND IN ACCORDANCE WITH OWNERSHIP/PREVIOUS RECORD.
2. THE ENGINEER IS FULLY RESPONSIBLE FOR LAYING OUT THE PLOT, SPACING AND MARGINS.
3. THE DEPTH AND POSITION OF EXISTING MUNICIPAL MAINS AS VERIFIED BY ME ON SITE AND PREMISES CAN GET DRAMATIC CONNECTION.
4. IT IS CERTIFIED THAT ACCORDING TO G.O.D.C.R.-2017, ALL REQUIREMENTS OF THE BUILDING AND BUILDING AND NECESSARY ACTIONS ARE TAKEN.
5. IT IS CERTIFIED THAT ACCORDING TO THE CLAUSE NO. 4.4.3 OF THE G.O.D.C.R.-2017, THE STRUCTURE OF THE BUILDING IS DESIGNED AS PER THE NORMS OF THE INDIAN STANDARDS.
6. DESIGN OF STAIRCASE AND LANDING IS PROVIDED AS PER THE PROVISION OF THE CLAUSE NO. 13.1.11 AND 13.1.13 OF G.O.D.C.R.-2017.
7. FIRE STRIKE RAMP IS PROVIDED AS PER THE PROVISION OF THE CLAUSE NO. 13.1.14 OF G.O.D.C.R.-2017.
8. LIFT IS PROVIDED AS PER THE PROVISION OF THE CLAUSE NO. 13.1.15 OF G.O.D.C.R.-2017.
9. WATER TANK IS PROVIDED AS PER THE PROVISION OF THE CLAUSE NO. 13.8 OF G.O.D.C.R.-2017.
10. LIFT SHAFT FOR EACH UNIT SHALL BE PROVIDED AT GROUND FLOOR LEVEL FOR EACH UNIT.
11. WATER TANK FOR FIRE SAFETY REQUIREMENT PROVIDED AS PER FIRE PREVENTION AND FIRE SAFETY ACT-2018.
12. ELECTRICAL INFRASTRUCTURE SHALL BE PROVIDED AS PER CLAUSE NO. 13.1.11 OF G.O.D.C.R.-2017.
13. DRAINAGE WATER FACILITY FOR EACH UNIT PROVIDED AS PER CLAUSE NO. 13.8.1 OF G.O.D.C.R.-2017.
14. DRAINAGE FACILITY IS PROVIDED AS PER THE CLAUSE NO. 13.10 OF G.O.D.C.R.-2017.
15. SIGNAGES OF THE PARKING PLACE IS TO BE PROVIDED AS PER THE PROVISION OF THE CLAUSE NO. 13.7 OF G.O.D.C.R.-2017.
16. ENTRANCE OF THE BUILDING IS PROVIDED AS PER THE CLAUSE NO. 13.1.16 OF G.O.D.C.R.-2017.
17. THE PARKING OF BUILDING UNIT (PLOT) AS PER THE PROVISION OF THE CLAUSE NO. 13.1.13 OF G.O.D.C.R.-2017.
18. THE STRUCTURAL DESIGN OF BUILDING IS AS PER NORMS OF SPECIFIED IN THE INDIAN STANDARDS AND NECESSARY ACTION SHALL BE TAKEN FOR THE STRUCTURAL SAFETY DURING CONSTRUCTION.
19. RAIN WATER STORAGE TANK AND RAIN WATER HARVESTING SYSTEM SHALL BE PROVIDED AS PER CLAUSE NO. 13.7 OF G.O.D.C.R.-2017.
20. COMMUNITY BIN PROVIDED AS PER THE PROVISION OF THE CLAUSE NO. 17.2.4 OF G.O.D.C.R.-2017.
21. GREY WATER RECYCLING SYSTEM & DUAL PLUMBING SYSTEM IS PROVIDED AS PER THE CLAUSE NO. 17.3 OF G.O.D.C.R.-2017.
22. FIRE PREVENTION IS PROVIDED AS PER THE CLAUSE NO. 17.4 OF G.O.D.C.R.-2017.
23. SOLAR ASSISTED WATER HEATING SYSTEM SHALL BE PROVIDED AS PER CLAUSE NO. 17.5 OF G.O.D.C.R.-2017.
24. HYDRANT CONTROL SYSTEM IS PROVIDED AS PER THE CLAUSE NO. 18 OF G.O.D.C.R.-2017.
25. FIRE SAFETY SYSTEM IS PROVIDED AS PER CHAPTER 19 OF G.O.D.C.R.-2017.
26. FIRE SAFETY PROVISION SHALL BE MADE AS PER FIRE PREVENTION AND LIFE SAFETY MEASURES REGULATION-2016 AND FIRE PREVENTION AND LIFE SAFETY MEASURES REGULATION-2013.
27. MAINTENANCE AND REPAIRING OF BUILDING IS AS PER CHAPTER NO. 19 OF G.O.D.C.R.-2017.
28. MARSHAL SPACE BASEMENT SHALL HAVE LOADING CAPACITY OF 4000 TONS PER SQUARE METER SHALL BE PROVIDED AS PER CHAPTER NO. 19 OF G.O.D.C.R.-2017 AND THE PROVISION OF THE SAFETY ACT-2018.
29. ROOF TOP SOLAR ENERGY INSTALLATION & OPERATION SHALL BE PROVIDED AS PER CLAUSE NO. 17.1.1 OF G.O.D.C.R.-2017.
30. THE GRADED SURFACE AREA OF THE EXTERIOR FACADE SHALL BE PROVIDED AS PER CLAUSE NO. 17.1.1 OF G.O.D.C.R.-2017.
31. THE TOTAL SURFACE AREA OF EACH FACADE WITH THE PROVISION OF SAFETY MAINTAIN UP TO 5% LEVEL AS PER CLAUSE NO. 13.13 OF G.O.D.C.R.-2017.

The basic requirements for fire protection Highrise buildings:
1) Hydrant system
ON/OFF switches located near the hose reel hose or hydrant outlet at each floor for the main fire pump at the underground water tank with a capacity to discharge 900 ltr per min at 3 bar pressure measured at the hose reel level should be installed.
2) Hose reel
For the buildings exceeding 18 meters height should not be of less than 100mm internal diameter. The hose should be connected to the bottom of the hose reel tank with a stop valve and a NFV to act as a Down-cum.
3) Hose reel
One hose is required for every 100sq. meters floor area and if the building is divided into two or more parts then each part should have a separate hose reel with all the fittings at floor level.
4) Hose reel
Each floor should have one hydrant outlet with a coupling for attaching a 65mm dia. hose & 25mm bore hose reel hose with 8mm SS shut-off nozzle at each floor level. The length of the hose reel hose should be enough to reach the furthest corner of the floor. Hose-box with 15 meters long 65mm dia. hose and 12.5mm bore nozzle at alternate floors. The 65mm dia. hose should be coupled to the hose reel.
5) Fire service inlet
Fire service inlet should be installed at a point near the entry to the premises where a fire service vehicle can approach easily.
6) Permanent hydrant point
A permanent hydrant point comprising of 63 mm dia size 2nos of hydrant valves should be installed at the terrace level.
7) Overhead tank
Overhead tank with all fittings connections should be done at the terrace level. The overhead tank shall be of a capacity of not less than 20,000 liters. The underground tank shall be of not less than 1,00,000 liters.
8) Fire lift
The fire lift and all lifts should have a provision to ground automatically in case of electric failure, each building should have at least one lift as a fire lift and if the building is divided into two or more parts then each part should have a fire-LIFT. Lift-well should have blowers to pressure the lift well so connected that it will automatically lift getting smoke logged.
9) Fire alarm
Fire alarm call point to be installed at each floor with sounders capable of being heard all throughout the building.
10) Fire extinguishers
4) Fire extinguishers
One Carbon Dioxide (CO2) type extinguisher of 4.5kg with ISI mark, and one extinguisher of 3kg Dry chemical powder (DCP) type extinguisher with ISI mark to be installed on each floor in case of commercial building.
One Carbon Dioxide (CO2) type extinguisher of 4.5 kg with ISI mark, and one Carbon Dioxide (CO2) type extinguisher of 3kg, with ISI mark capacity on alternate floors in case of residential building.
If the building is divided into two or more parts then each part should have these extinguishers installed.
5) Staircases
The staircase has to be open from at least one or two side but if the staircase is in the center core of the building it has to be pressurized to prevent it getting smoke logged.
6) Basement
The basement of 200sq. meter or more should be protected with: Automatic sprinkler system with at least one sprinkler head for actual car parking space.
Additionally be protected by a Hydrant outlet and two 25mm bore hose-reel hoses with 8 mm. bore nozzles at each basement level.
7) Lightning arrester
A lightning arrester should also be installed and be properly earthed to prevent damage to the building when the lightning strikes.
8) Photo luminescent (auto glow) signages
If the building falls in a confined area or if it has an enclosed staircase or it not well lit-up on the inside, then adequate photo luminescent (auto glow) signages should be displayed at each floor / landing / pathway / dead-end and all exits leading to the ground level. The signages should indicate fire fighting, fire safety equipment present on the respective floor/landing/pathway/dead-end and along all exits leading to the ground level.
9) Electric power supply to the entire fire safety system
Electricity supply to the fire pump, fire alarm system, staircase pressurization system and fire lift should be made available from the main electrical supply (i.e. from electrical power supply of the company). This is to ensure availability of power supply to the fire protection & safety even after the main electrical supply to the building is switched off at the time of fire.
10) Individual fire safety system
Fire safety system should be provided in individual shop room by owner.
Important instructions:
After inspection of a low rise building by the fire service authority, if the fire officer concerned feels the need for additional fire prevention/protection measure (ventilation system required or equipment), i.e. passive system suppression system / fire door / window / detection system / active system / sprinkler / detector etc.) as per fire load / fire risk / public gathering potential / occupancy / confined area, those additional measures / equipment have to be implemented / installed.

CHANNEL FOR DRAINAGE SECTION 1
SCALE: HORIZ - 1 CM = 5 M
VERT - 1 CM = 1 M

SCRUTINIZE COPY
NO. 383-1-10/13/15/17/18/19/2171/

- [illegible]



100%

90%

80%

70%

60%

50%

40%

30%

20%

10%

0%

0

1

2

512

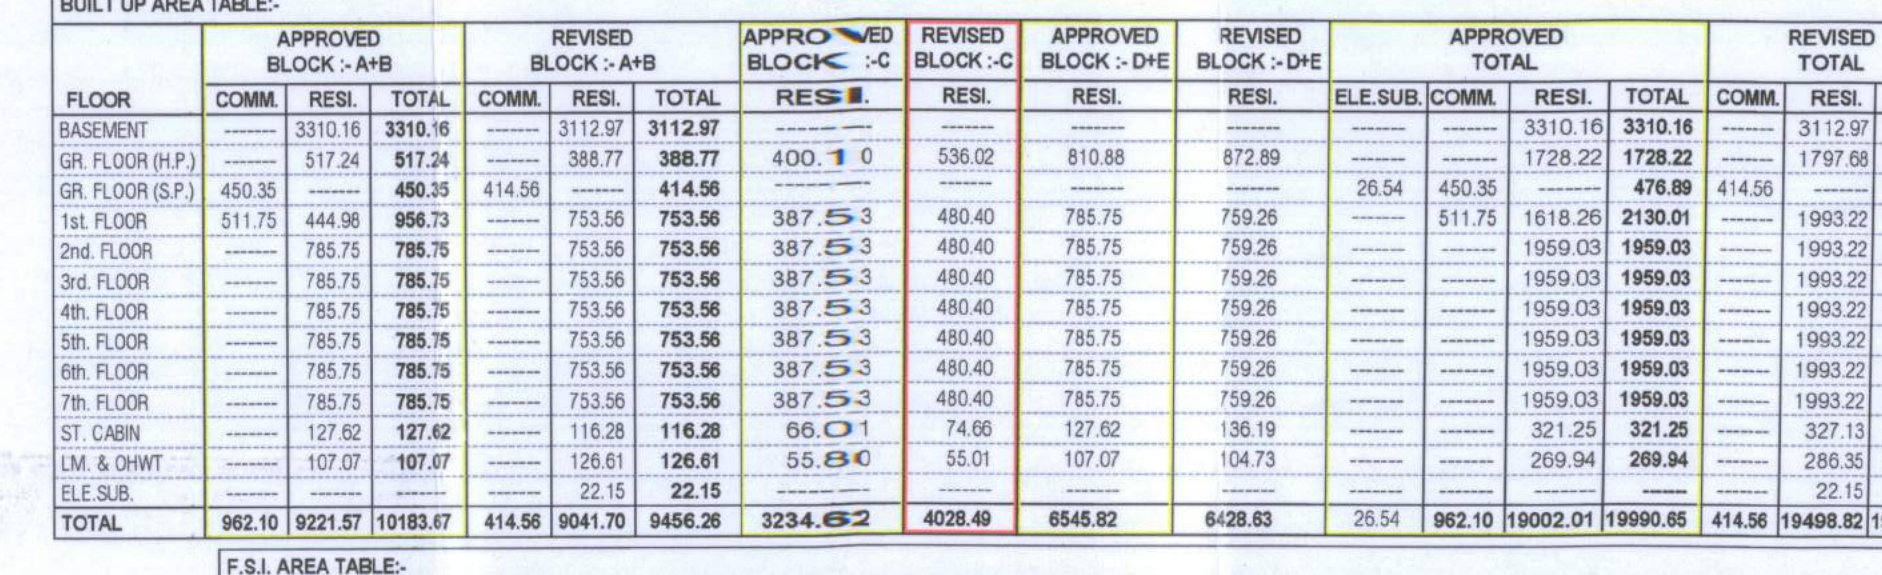
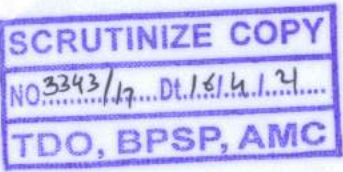
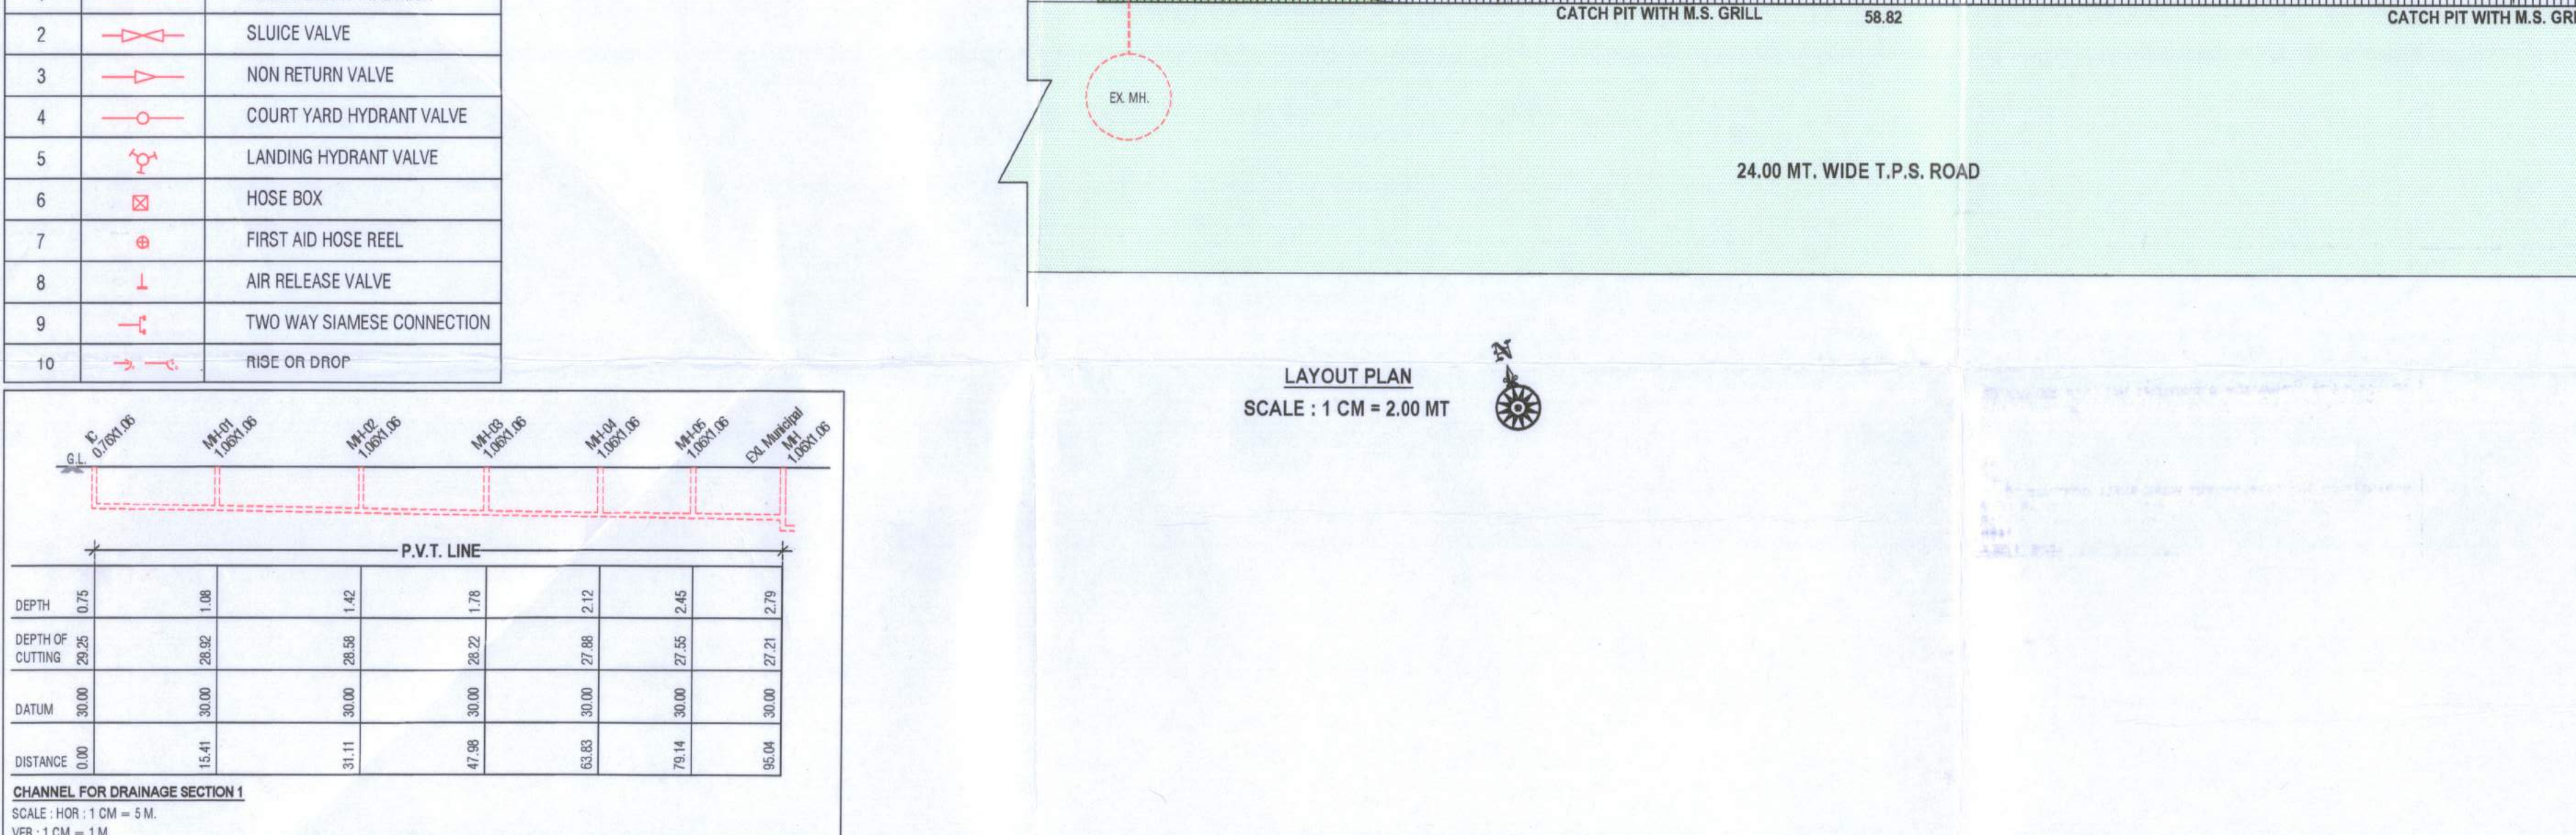
513

514

515

1.	PLOT AREA	4637.09					
2.	PERMISSIBLE FSQ	8348.27					
3.	PERMISSIBLE CHARGEABLE FSI	4174.14					
4.	MAX. PERMISSIBLE F.S.I. (2-B)	12322.41					
5.	TOTAL UTILIZED F.S.I.	11880.78					
6.	UTILIZED CHARGEABLE F.S.I. (5-D)	3029.61					
7.	MAX. PERMISSIBLE F.S.I. COMMERCIAL	1186.68					

GRAND TOTAL DETAILS							
S.NO.	DWELLING UNIT TYPE	NO. OF UNIT	USED F.S.I.	% USED F.S.I.	CHARGEABLE F.S.I.		
A	COMMERCIAL UNIT	12	407.31	3.38	119.04		
B	UP TO 50 SQ.MT.	00	0.00	0.00			
C	MORE THAN 50 AND UP TO 66	28	1843.94	15.54	546.98		
D	MORE THAN 66 AND UP TO 90	126	9253.53	81.08	2854.82		
E	WITH AFF. F.S.I. (40% SLAB)	---	0.00	0.00			
	GRAND TOTAL	166	11880.78	100.00	3029.61		

[illegible]

REQ. SANITARY 4.00 SQ MT CARPET AREA = 1 PERSONS
TOTAL CARPET AREA = 401.31 SMT.
 $401.31 / 04 = 100.33$ PERSONS
SAY = 100 PERSONS

100/50 = 2.00 Say = 2.00	Total Provide 12 Nos.
1.00 Male wc & 1.00 Female wc	General 02 Nos.
One Toilet Provided in Each Shop	
25 % Sanitary For General Public	
Urinal = $2 \times 0.25 = 0.50$ Say = 01 For Male	
W.c = $2 \times 0.25 = 0.50$ Say = 01 For Female	
One Special Toilet For Handicap Person	

COMMON PLOT AREA	
(A)	17
	TO
NET COMMON PLOT	

Diagram illustrating an air vent through a RCC slab. The air vent is shown as a vertical pipe with a cap on top. Labels include "AIR VENT" pointing to the cap, "RCC SLAB" pointing to the horizontal section, and "G.L." (Ground Level) pointing to the base of the slab.



ACQUIRIRI
10.00 MT.

250MM DIA. STAINER
600MM DIA. BORE
125MM DIA. GRAVE
STAINER

PERCOLATION WELL
(PLOT AREA > 4000 SQ. MT.)

MT. WIDE T.P.S. ROAD

SCALE : 1 CM = 2.00 MT		SHEET NO. - 01
USE ZONE : RESIDENTIAL-1 (R1), INDUSTRIAL ZONE GENERAL (IG) & OVERLAY RAH ZONE		
USE : COMM+RESI. (RAH)		
AREA TABLE :		
	TOTAL	TOTAL
	APPROVED	REVISE
PLOT AREA OF S.P.-141/12 OF F.P. NO.-141	4637.93	4637.93
REQ. COMMON PLOT @ 10 %		467.39

PERM. F.S.I. AREA (1:1.8) 4637.93 X 1.8	8348.27	8348.27
CHARGEABLE F.S.I. @ 0.9 OF PLOT AREA (4637.93 X 0.90)	4174.14	4174.14
TOTAL PERMISSIBLE F.S.I.	12522.41	12522.41
TOTAL USE F.S.I.	11772.03	11868.78
TOTAL CHARGEABLE F.S.I. (11868.78-8348.27)	3420.51	3420.51
BUILT UP AREA TABLE	SQMT	SQMT

BUILT UP AREA ON BASEMENT	3310.16	3112.97
BUILT UP AREA ON GROUND FLOOR (H.P)	1728.22	1797.68
BUILT UP AREA ON GROUND FLOOR (S.P)	476.89	414.56
BUILT UP AREA ON FIRST FLOOR	2130.01	1963.22
BUILT UP AREA ON SECOND FLOOR	1859.03	1963.22
BUILT UP AREA ON THIRD FLOOR	1959.03	1963.22

BUILT UP AREA ON FIFTH FLOOR	1959.03	1993.22	
BUILT UP AREA ON SIXTH FLOOR	1959.03	1993.22	
BUILT UP AREA ON SEVENTH FLOOR	1959.03	1993.22	
BUILT UP AREA ON STAIR CABIN	321.25	327.13	
BUILT UP AREA ON LIFT MACHINE RM & O.H.W.T	269.94	286.35	
BUILT UP AREA ON ELE S.S.	*****	22.15	

AREA TABLE	SQMT	SQMT
F.S.J AREA ON GROUND FLOOR (S.P)	APPROVED	REVISE
F.S.J AREA ON FIRST FLOOR	474.97	401.31
F.S.J AREA ON SECOND FLOOR	1750.58	1638.21
F.S.J AREA ON THIRD FLOOR	1591.08	1638.21
	1591.06	1638.21

F.S.I AREA ON FIFTH FLOOR	1591.08	1638.21
F.S.I AREA ON SIXTH FLOOR	1591.08	1638.21
F.S.I AREA ON SEVENTH FLOOR	1591.08	1638.21
TOTAL F.S.I AREA	11772.03	11868.78

R.C.C. STAIR DETAIL :-	COLOUR NOTE :-
------------------------	----------------

0.15 MT. RISER		PERM. DRAINAGE		CONTAINER BIN
		ROAD		PERCOLATING WELL
		PLOT BOUNDARY		PROP. DUAL PLUMBING SYSTEM
		APPROVED WORK		

CONTAINER BIN CALC. (COMMERCIAL) 10 LTR CAPACITY FOR EACH 100 S.M.T FL AREA POP C.B.=401.31/ 100 X 20 = 80.261 FEELS	CONTAINER BIN CALC. (RESIDENTIAL) TOTAL NO. OF UNIT 154
--	--

40 LBS CONTAINER BIN RES: 20 + COMA 1 = 21 PROV. CONTAINER BIN = 21.00 NOS.	80 LTRS = 6 UNITS TOTAL NO. = 154/6 = 19.25 RED. REFUSED CONT. = 20.00 NOS.
PERCOLATING WELL CALC:- IN NOS.	PROV. CONTAINER BIN = 20.00 NOS.
REQ. 1500 TO 4000 SMT = 1.00 NOS. 337.93/4000.00 = 1.15 NOS. 4Y REQ. P.WELL = 2.00 NOS.	TREE PLANTATION CALC:- IN NOS. REQ. 200.00 SGMT = 5 TREE

257-09 272621 CHATURBHAI B. GEVARIYA AUTHO SIGN : CHATURBHAI B. GEVARIYA DEVI OFFERS I C NO : 475069820	PROVIDE TREE = 116 NOS.
	Nakrani Sp. CHIRAGKUMAR P. NAKRANI (B.E.CIVIL) 4/101 Shantiniketan 3 Opp. Rastogi

NIKOL, AHMEDABAD-382350,	AMC lic no. ER - 1163280522 AMC lic no. CW - 0665210720
DEVELOPER	C.O.W / ENGINEER

VALAY P. SHAH
Structural Designer (Grade-I)
AMC Lic. No. SD 0404220523R1
17, Shantikuni Soc., Bayad-

STR. ENGINEER	OWNER
	 HARSH DALSUKHBHAI TIMBADIYA (Chandniya Dhar, Amal, 265540)

SOR

The permission is valid only until the DP/TPS remains unaltered and further that the permission shall stand revoked as soon as there is change in DP/TPS with reference to the land under reference.

શહેરી સિવસત અને શહેરી મુકાબિલત વિભાગના ૫૪ કમ્પ્લેટ ન.
પરથી ૨૦૨૦ના ૧૬/૩/૨૦૨૧થી ૦૧-૦૪-૨૦૨૧-૨૦ ના ૫૪ સમુદાય વંશકામળી
બપરના મોટા સમુદાય મુકાબિલત વંશકામળી ૫૪ના સિવસત ૦૨નાં નોં.
૧૦૦થી મુકાબિલત શહેરી. —————

Ahmedabad Municipal Corporation

APPROVED as per terms and condition mentioned in the Commencement Certificate

Raja Chitthi Number : 04771080419/A2166/R/1M1

Date : 23/04/2021

CH. KJ. SL.

23/4/21

	T.D. Su Inspector (B.P.S.P.)	T.D. Inspector (B.P.S.P.)	Asst. T.D.O. (B.P.S.P.)	
				AUTHORITY