


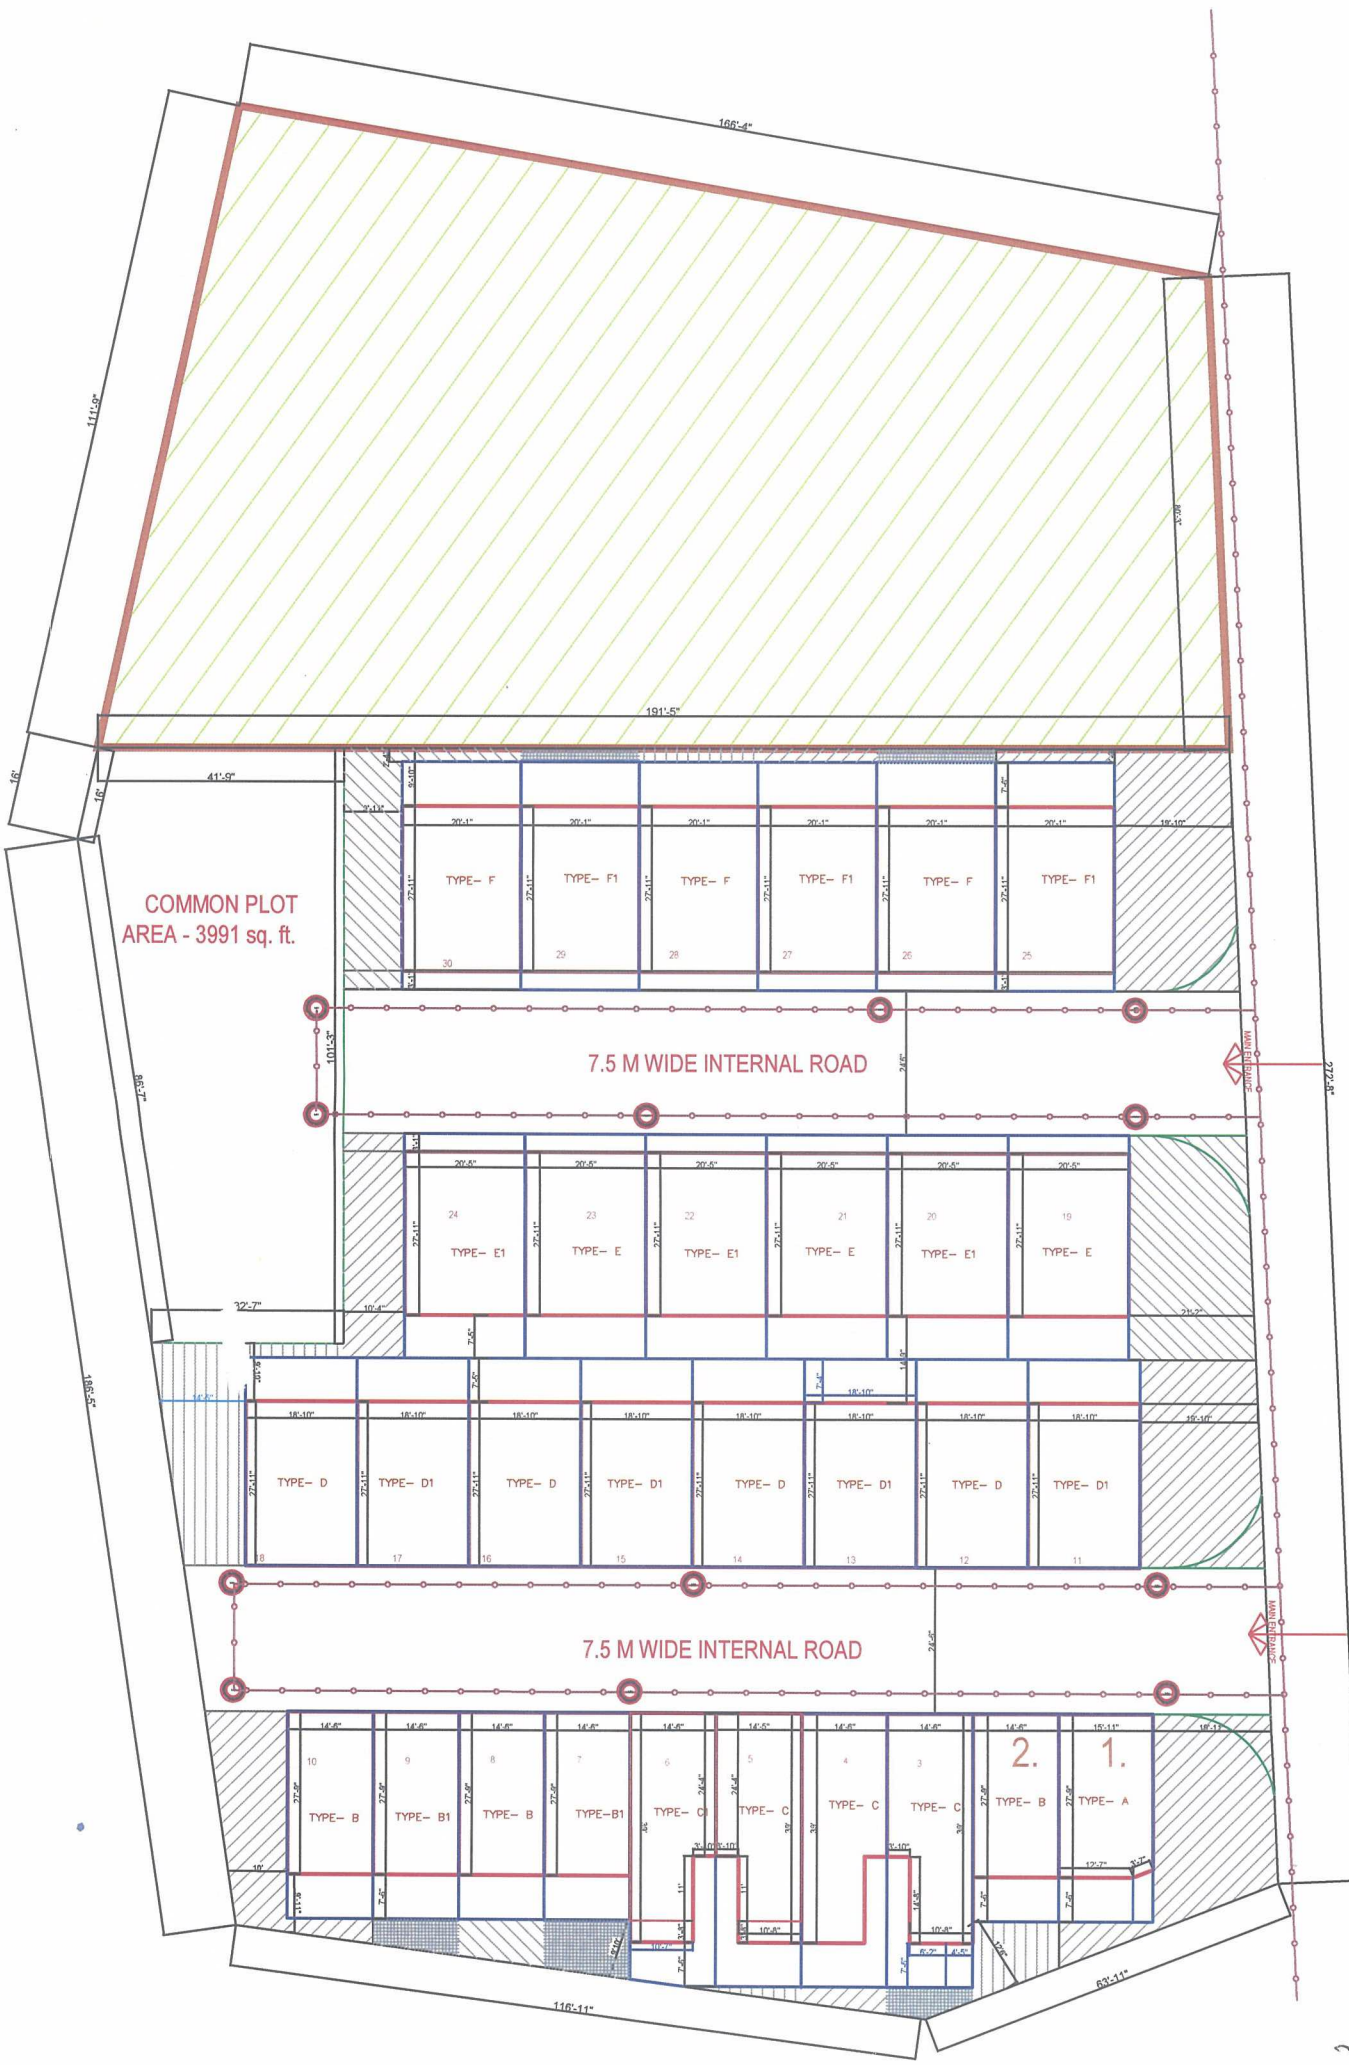

PLOT LINE

BUILT UP LINE

EXTRA LAN

DRAINAGE LINE

MANHOLE

LAYOUT PLAN

Kabir Developers
Partners
R.C. Patel
Ravi C. Patel

DRAWING TITLE- DRAINAGE LAYOUT
PROPOSED LAYOUT FOR - MR. RISHI DEVELOPERS



Manoj Patel DeSiGn StUdio
Scale : N.T.S
Date : 24-01-2023
Drg by : PRAJJWAL
Ar. Manoj Patel
B.Arch , M. Arch (CEPT) Green Building
M - 09924376644
E-Mail : manojpatelstudio@gmail.com

VADODARA