

Required Parking						
Building Name	Type	Subuse	Units		Required Parking	Other Parking
			Area			
						Visitor's Car

Building Name	Type	Subtype	Area		Units		Repaired Area(Sq.m)	Car Parking	Other Parking	Vehicular Parking
			Roof	Prop.	Roof	Prop.				
R (COM-EX)			> 0	1						
		ResComm	0 - 0	-	480.06	192.03	96.01	38.41		
		Merchante	0 - 1000	1000	-	-	-	-		
		Shop	> 0	1	47.03	190.61	95.40	38.16		
		Decoded Dwelling Unit	> 80.0	1	-	-	-	-		
	Residential Unit	0 - 0	-	1538.91	307.78	153.89	30.78			
	Total		-	-	650.62	346.30	107.55			

OWNERS NAME AND SOCIAL TYPE		PRANSHI BHARGAVA MALANI	
OWNERS NAME AND SOCIAL TYPE		<i>Pranishi Malani</i>	
particulars in part	ISSUES IN STOCKS	STRUCTURE EVOLVER	
DATE OF APPROVAL	10/08/2013 03:00:00		
DESCRIPTION OF APPROVER			


Layout Approved Details				
Layout Approved	Common CP Provided	Common Parking Provided	Sanction Date	Sanction No.
Yes	Yes	No		

Color Notes	Color Index

Floor Name	Building Volume N (Cm³/ft³)	Total	
		Total Floorboard Area (Sq.mt)	Total SSI Area (Sq.mt)
Ground floor	872.58	872.58	482.05
First floor	830.48	830.48	441.98
Second floor	728.15	728.15	441.98
Third floor	641.98	641.98	441.98
Fourth floor	102.99	102.99	0.00
Roof	3567.95	3567.95	2468.02


Project Title : PROPOSED COMMERCIAL CUM RESIDENCE BUILDING PLAN FOR PLOT NO.1-2-3, R.S.NO. -335 P/1 & 335 P/2, ROYAL PARK, SHIHOR, DIST. : BHAVNAGAR.OWNER NAME : MALKANI IRFANBHAI RAHIMBHAI

Inward No	ODPS/2020/018772	Sheet	3
Inward Date		Scale	1:100

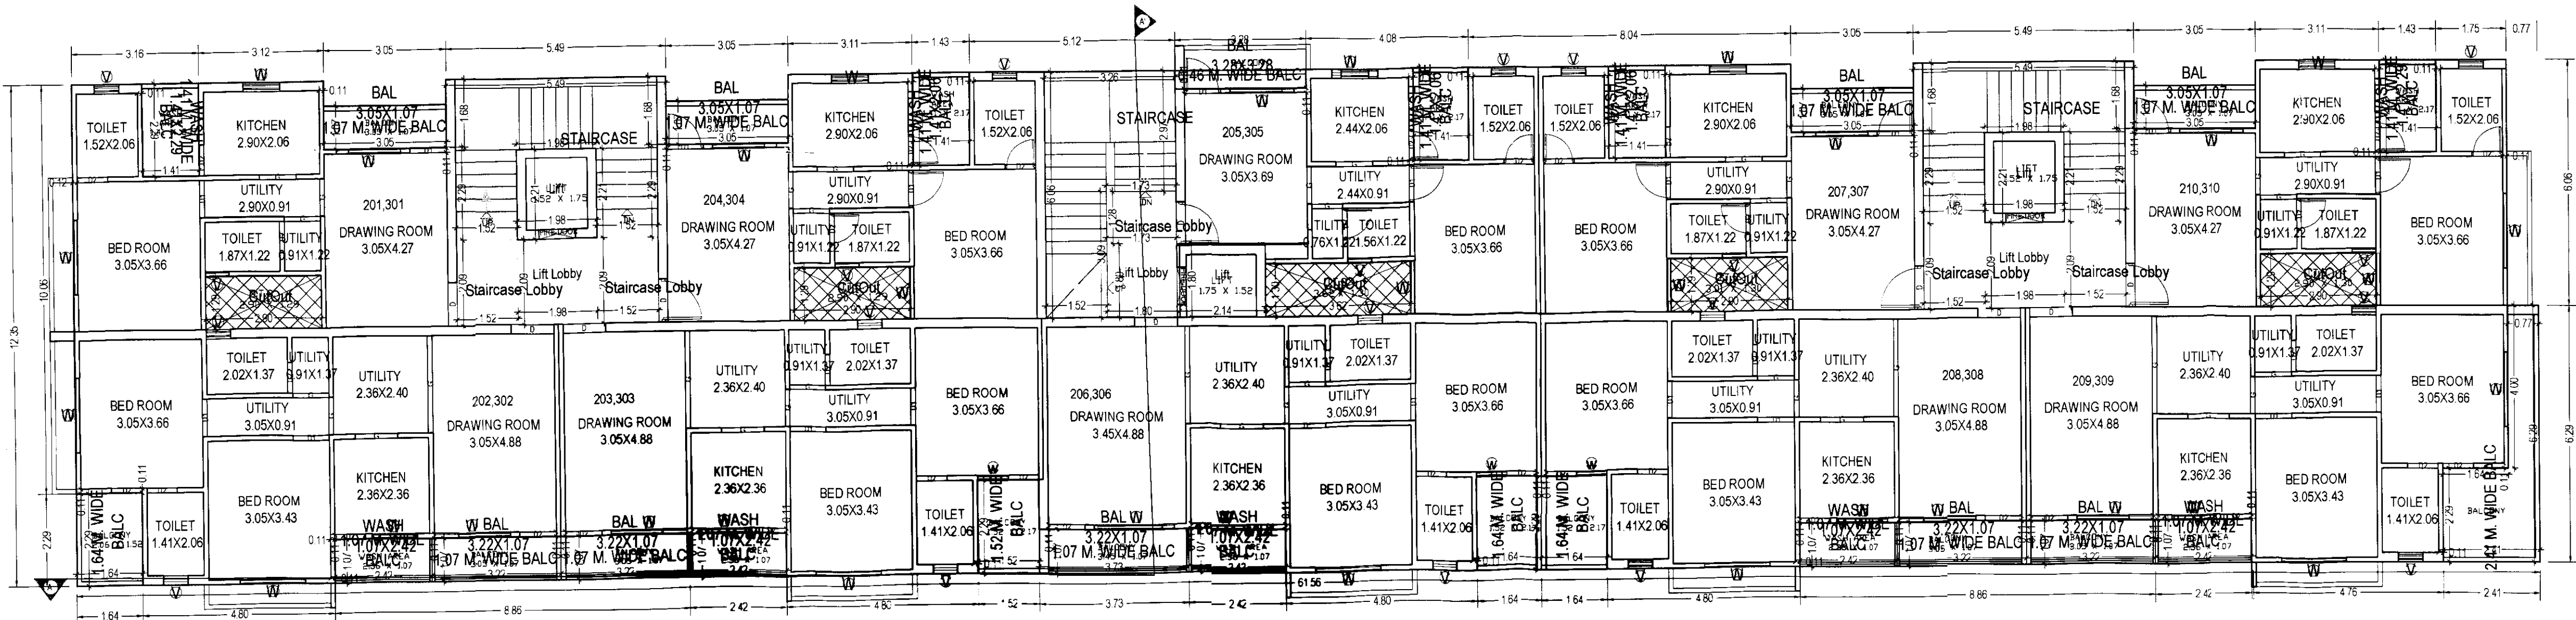


SECOND & THIRD FLOOR PLAN

TYPICAL - 2& 3 FLOOR PLAN
(Proposed)
(SCALE 1:100)

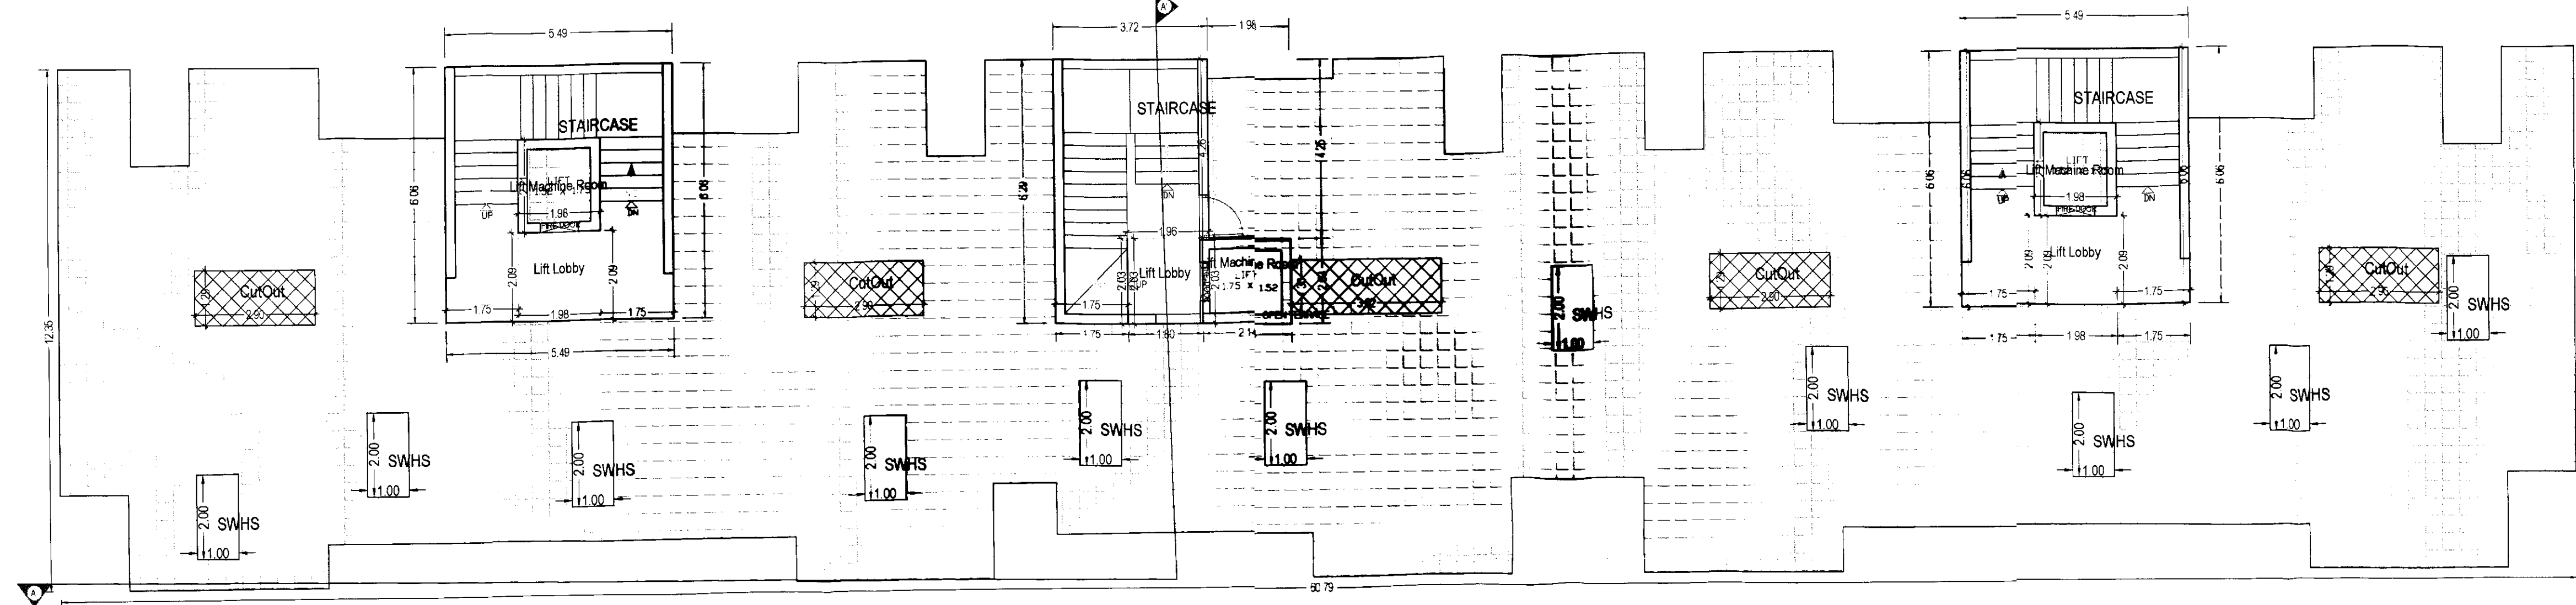

SECOND & THIRD FLOOR PLAN

TERRACE FLOOR PLAN
(SCALE 1:100)

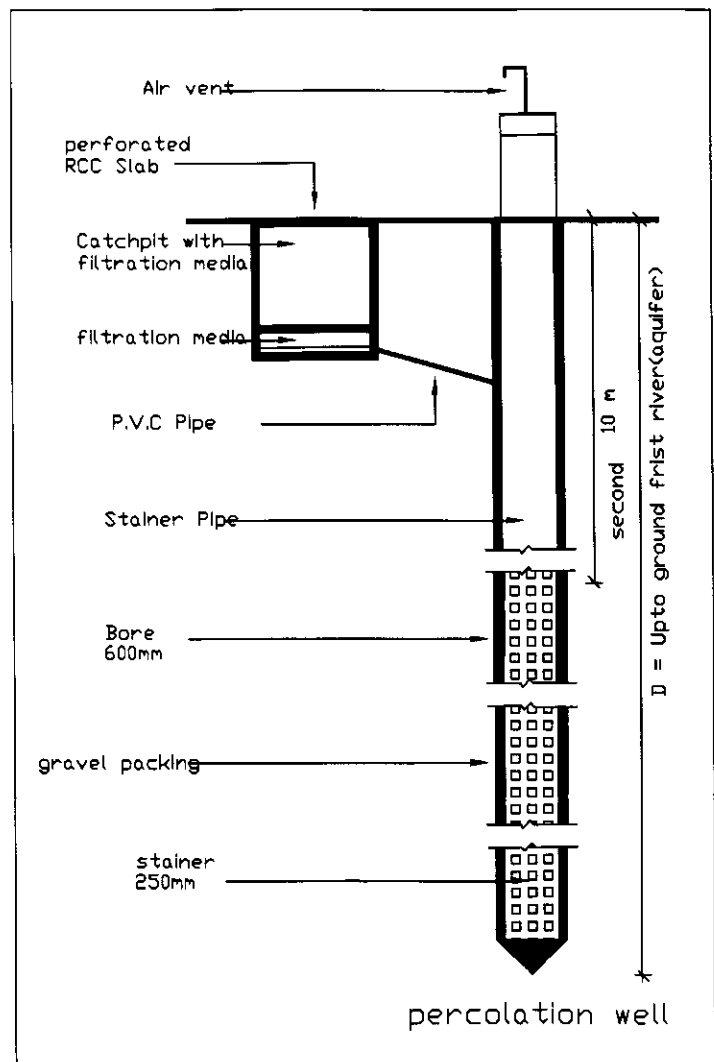

OWNER'S NAME AND SIGNATURE	
IRFANBHAI RAHIMBHAI MALKANI	
Irfan Malkani	
ARCHITECT'S NAME AND SIGNATURE	STRUCTURE ENGINEER
parthivbhai m purshit	
1098ER31032300001	
DATE OF APPROVAL	
DESIGNATION OF APPROVER	
QR Code	
Barcode	