
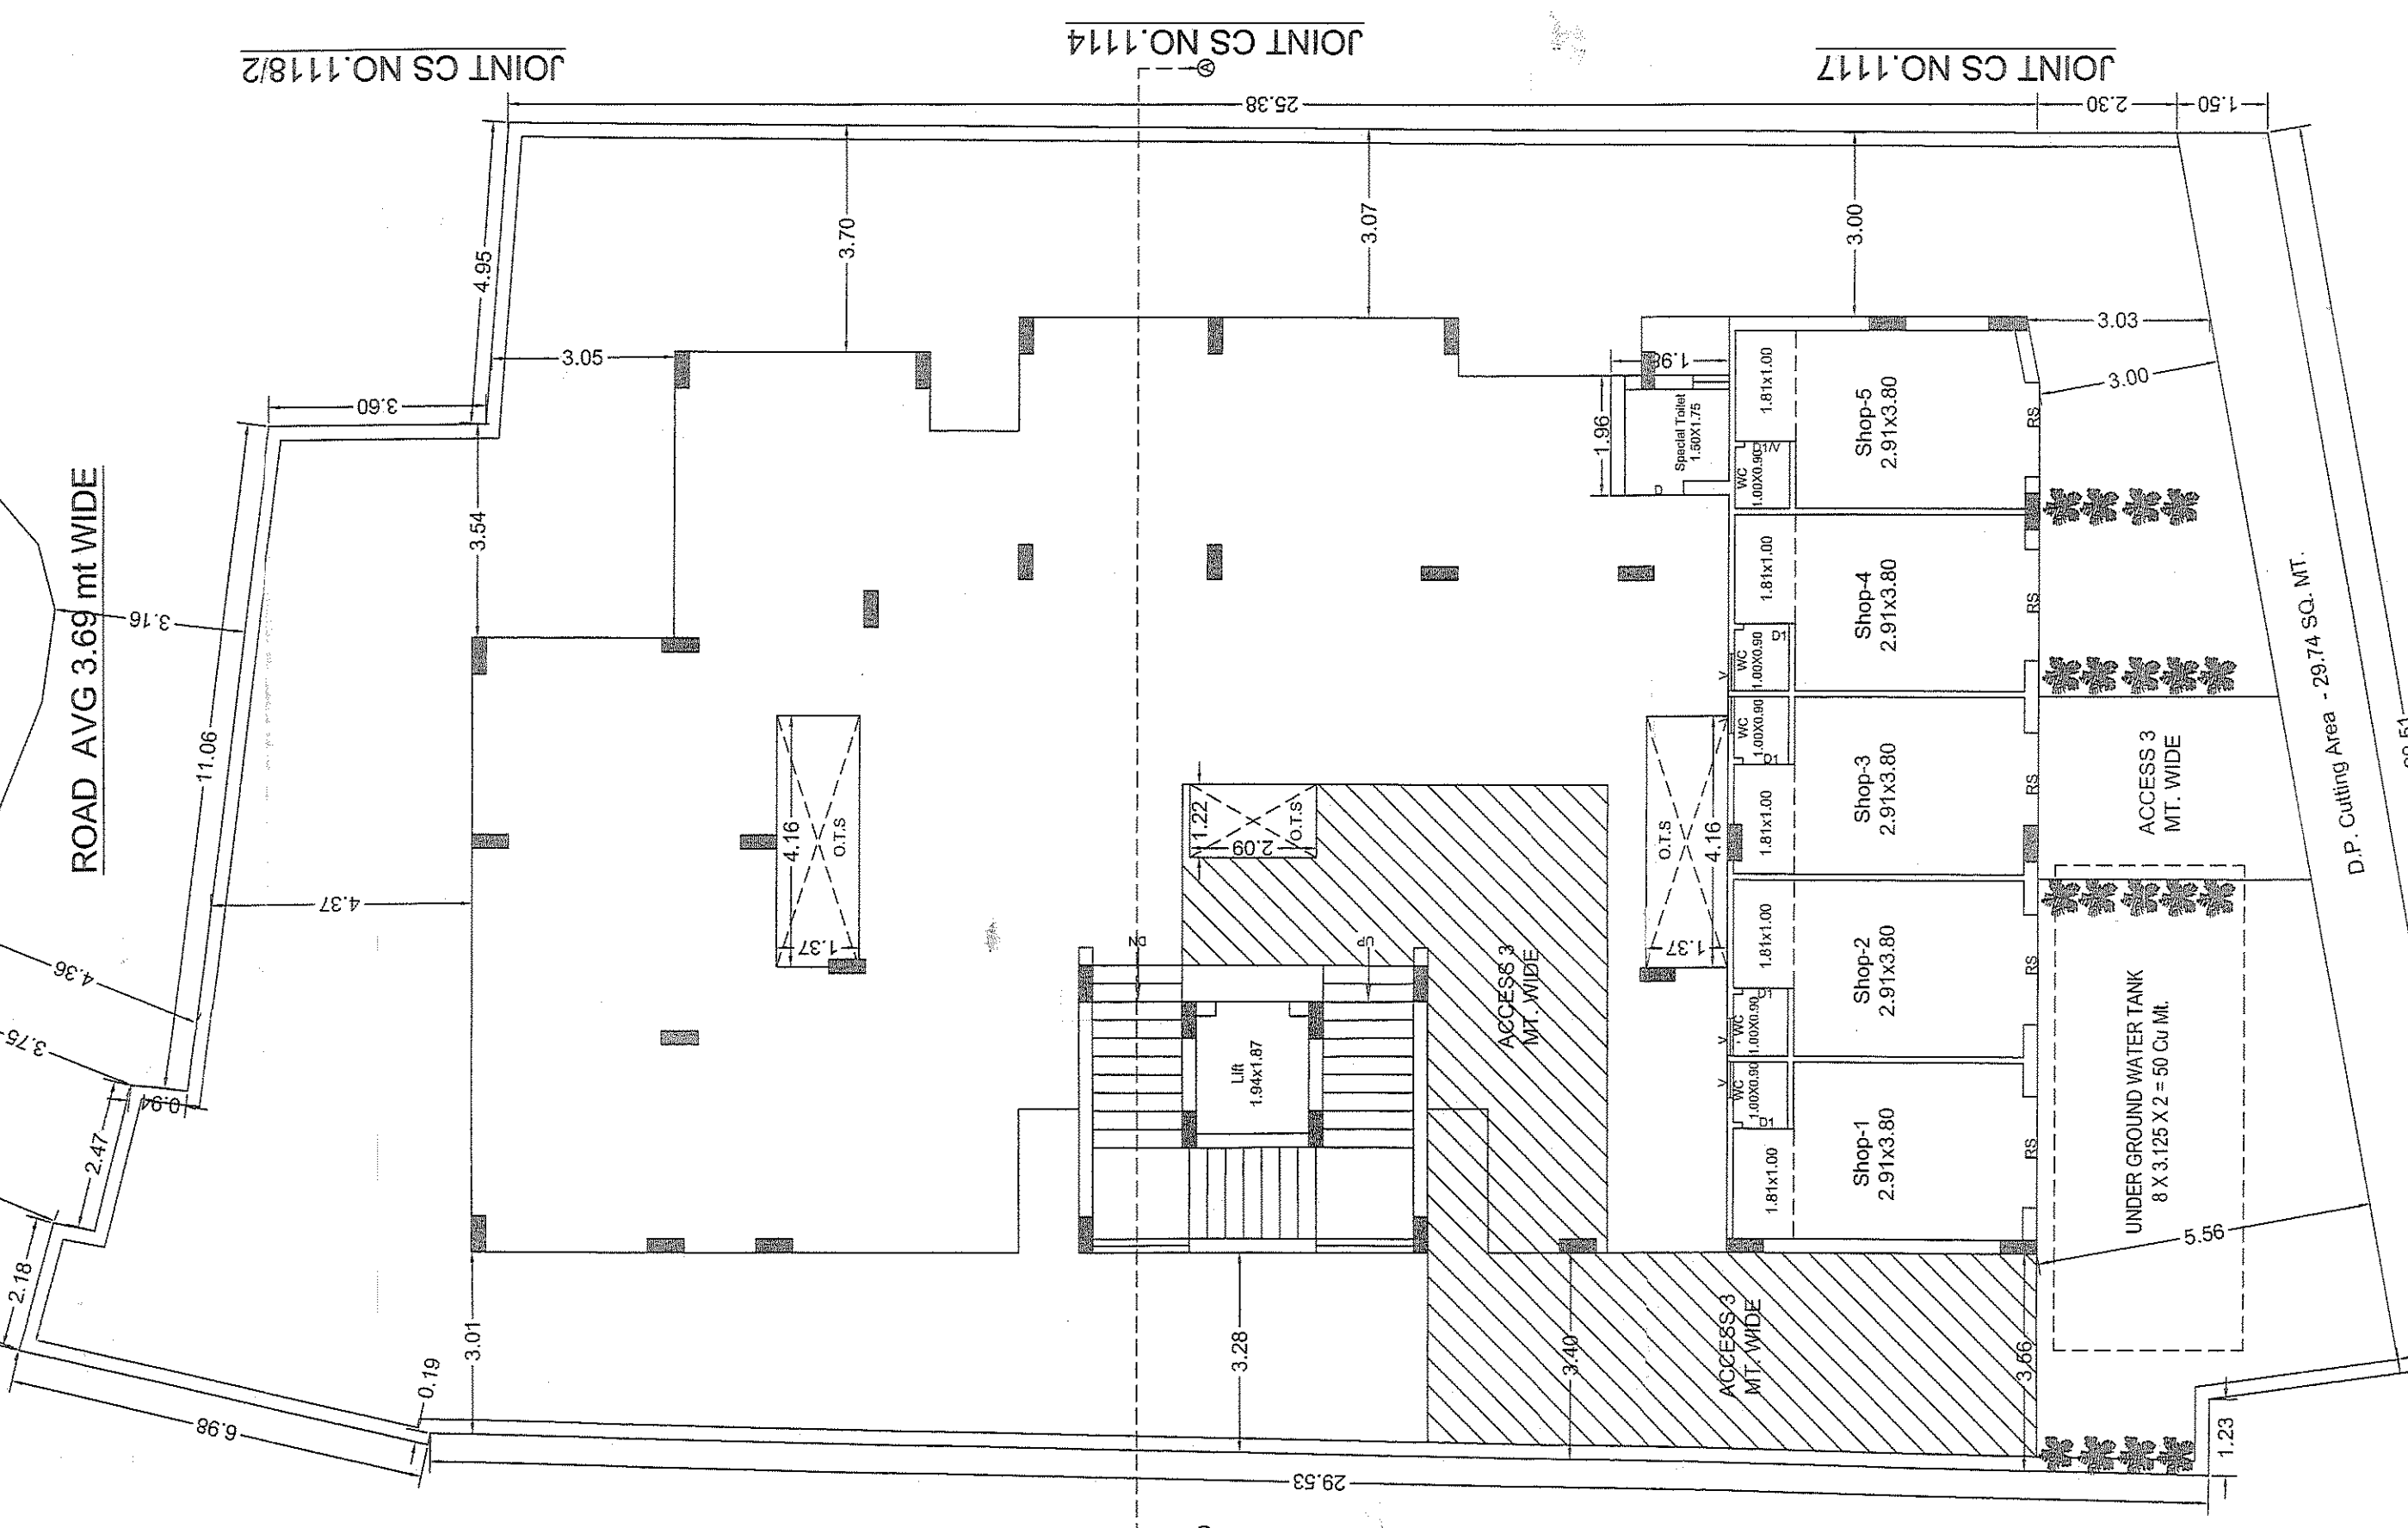
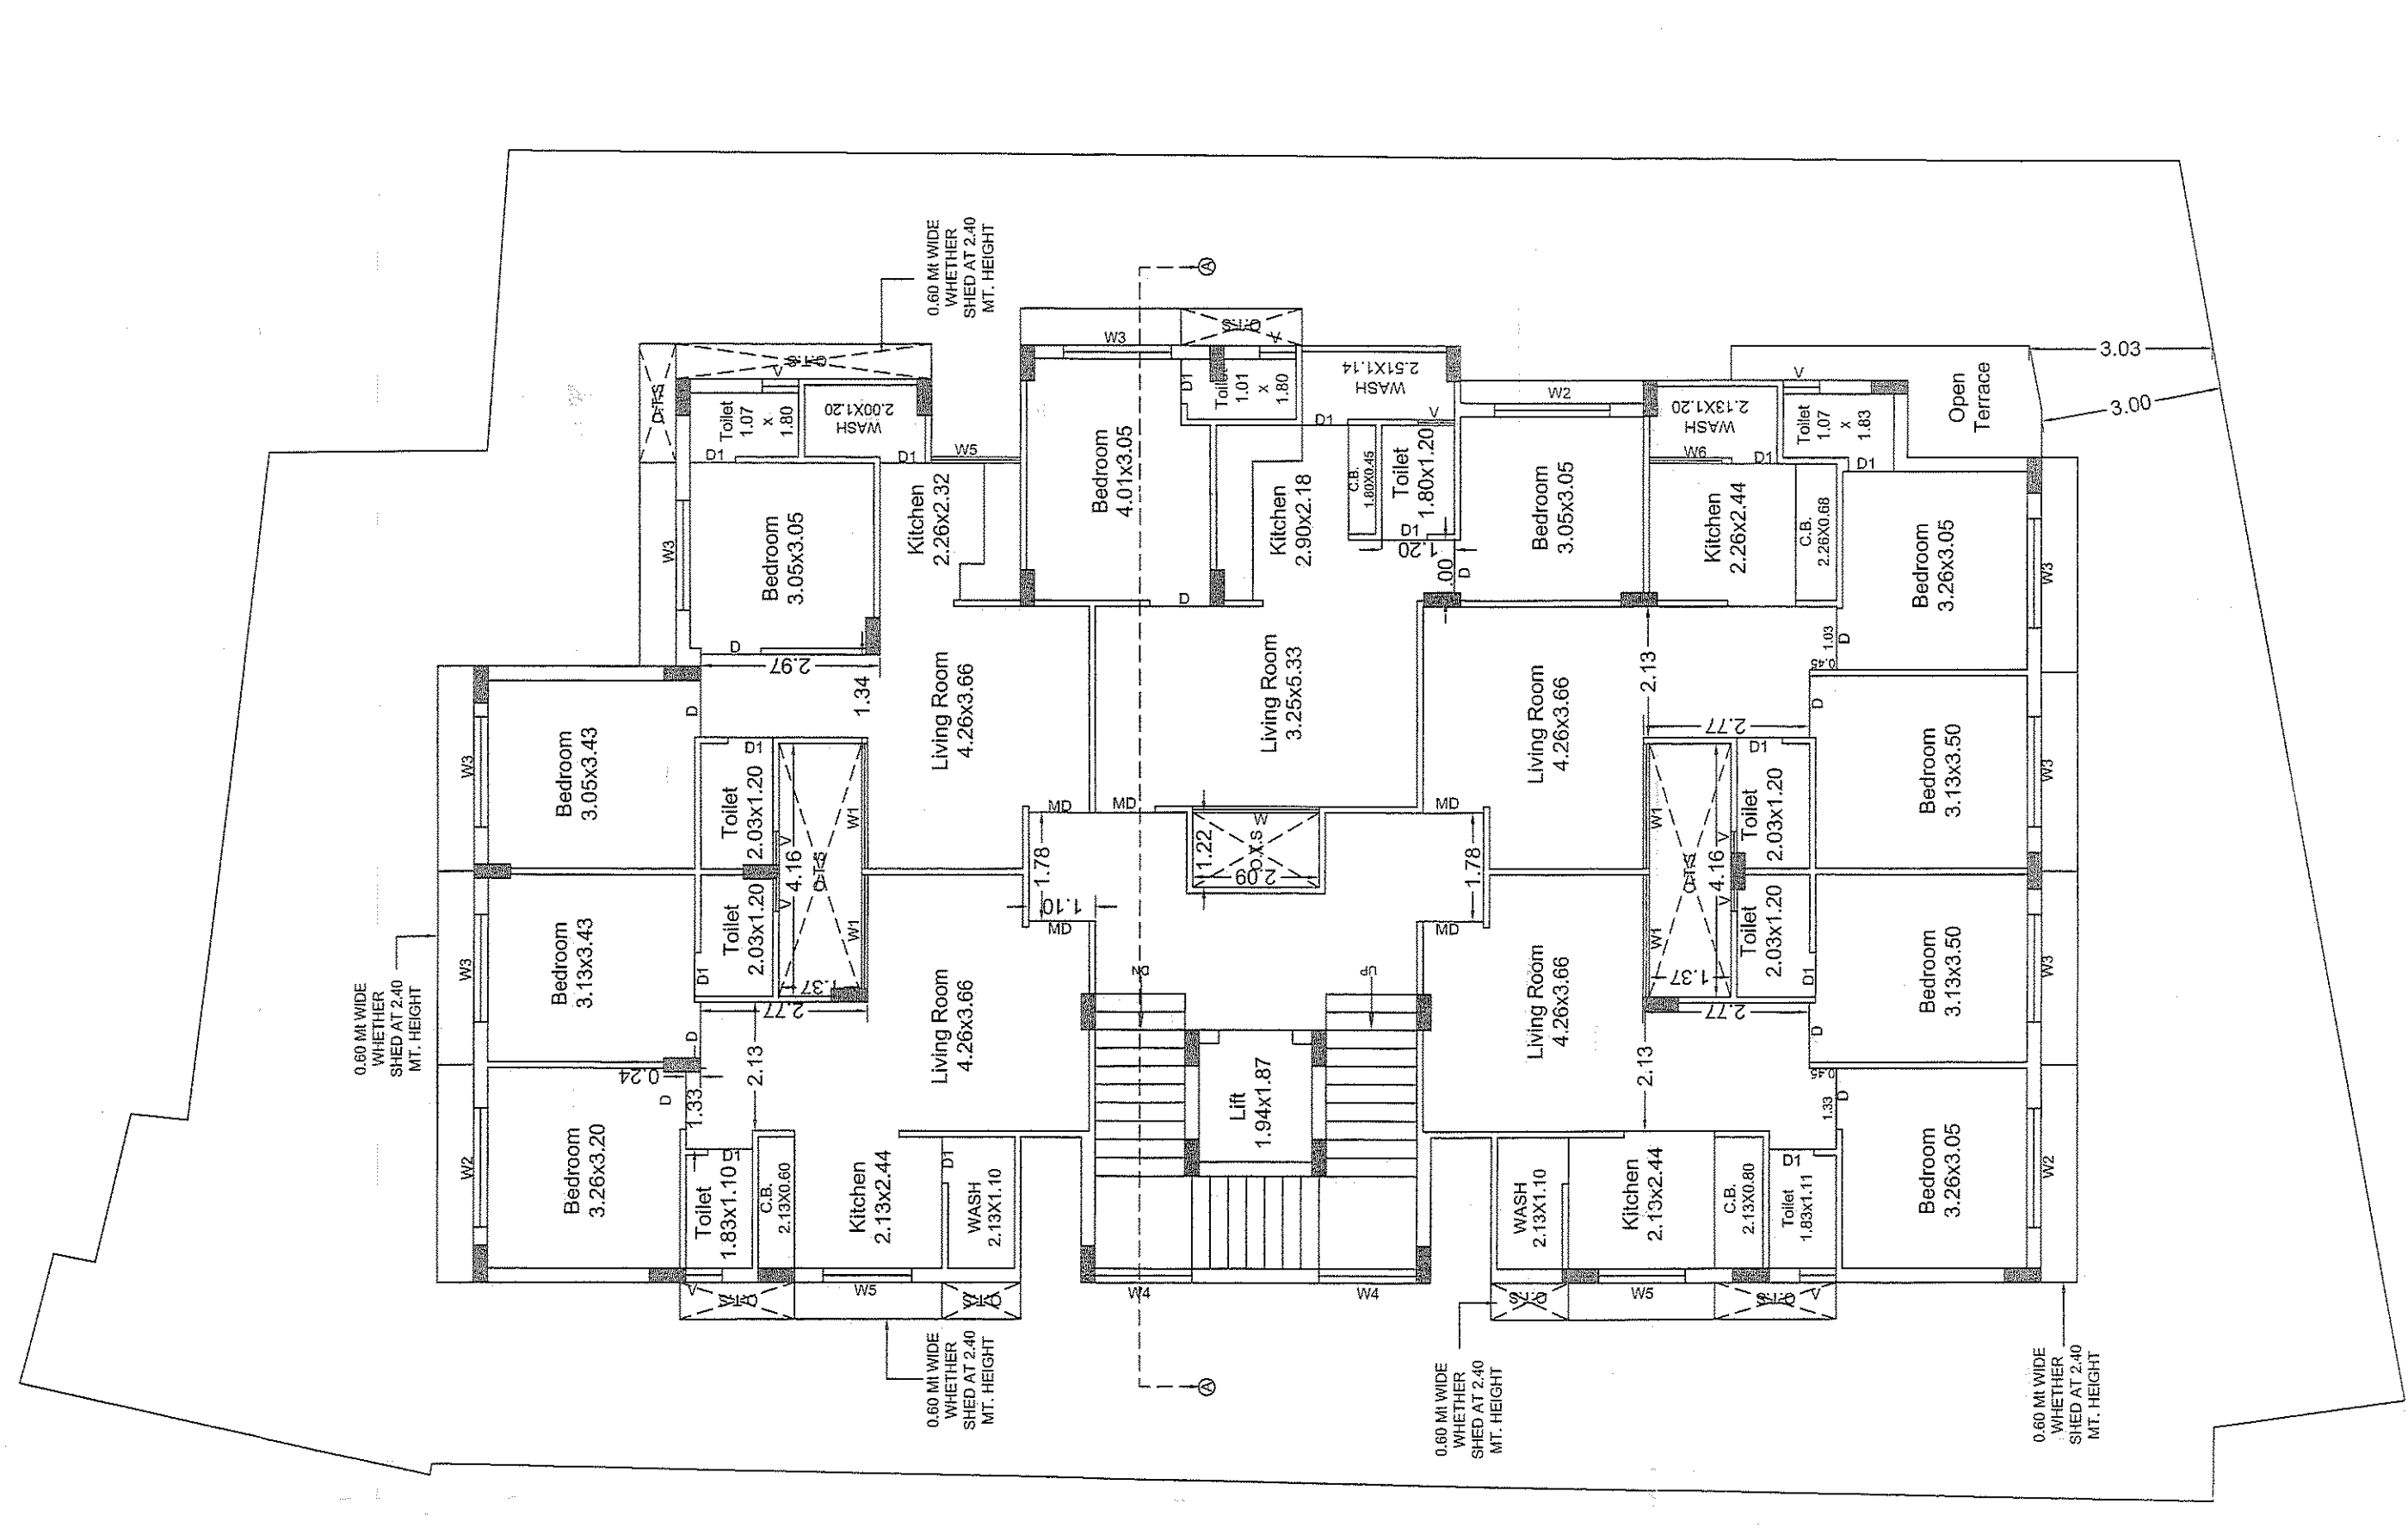
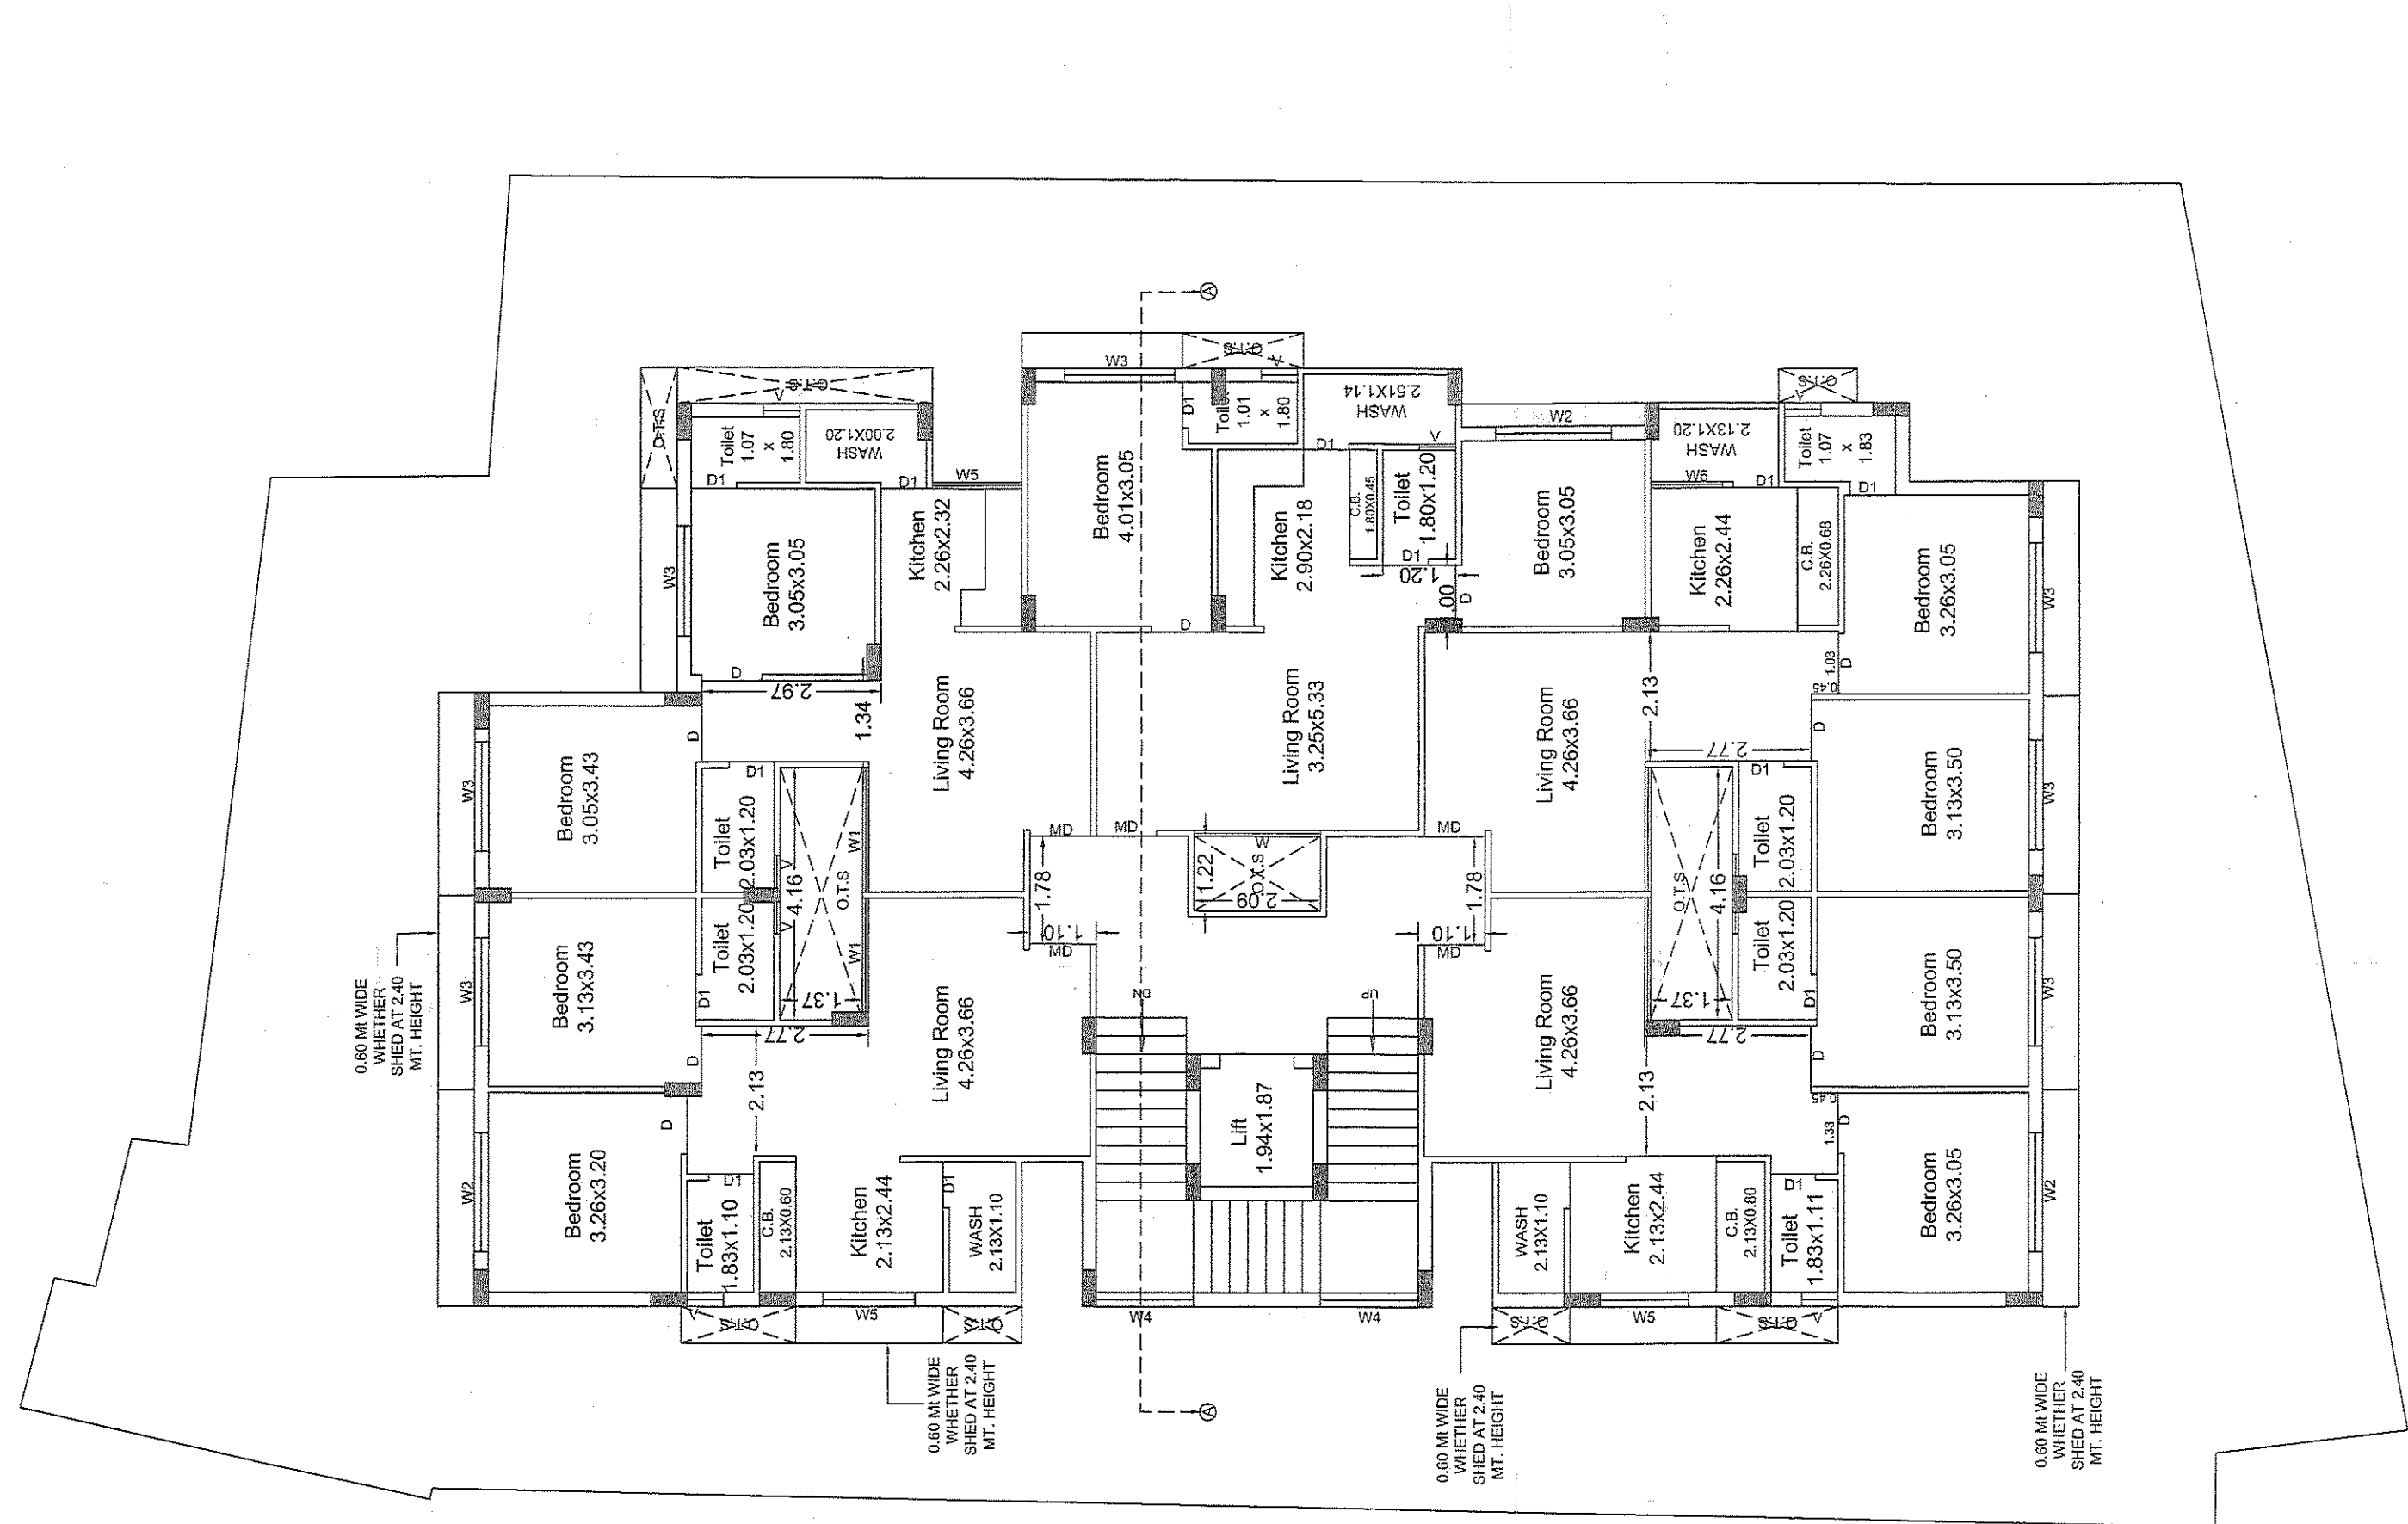
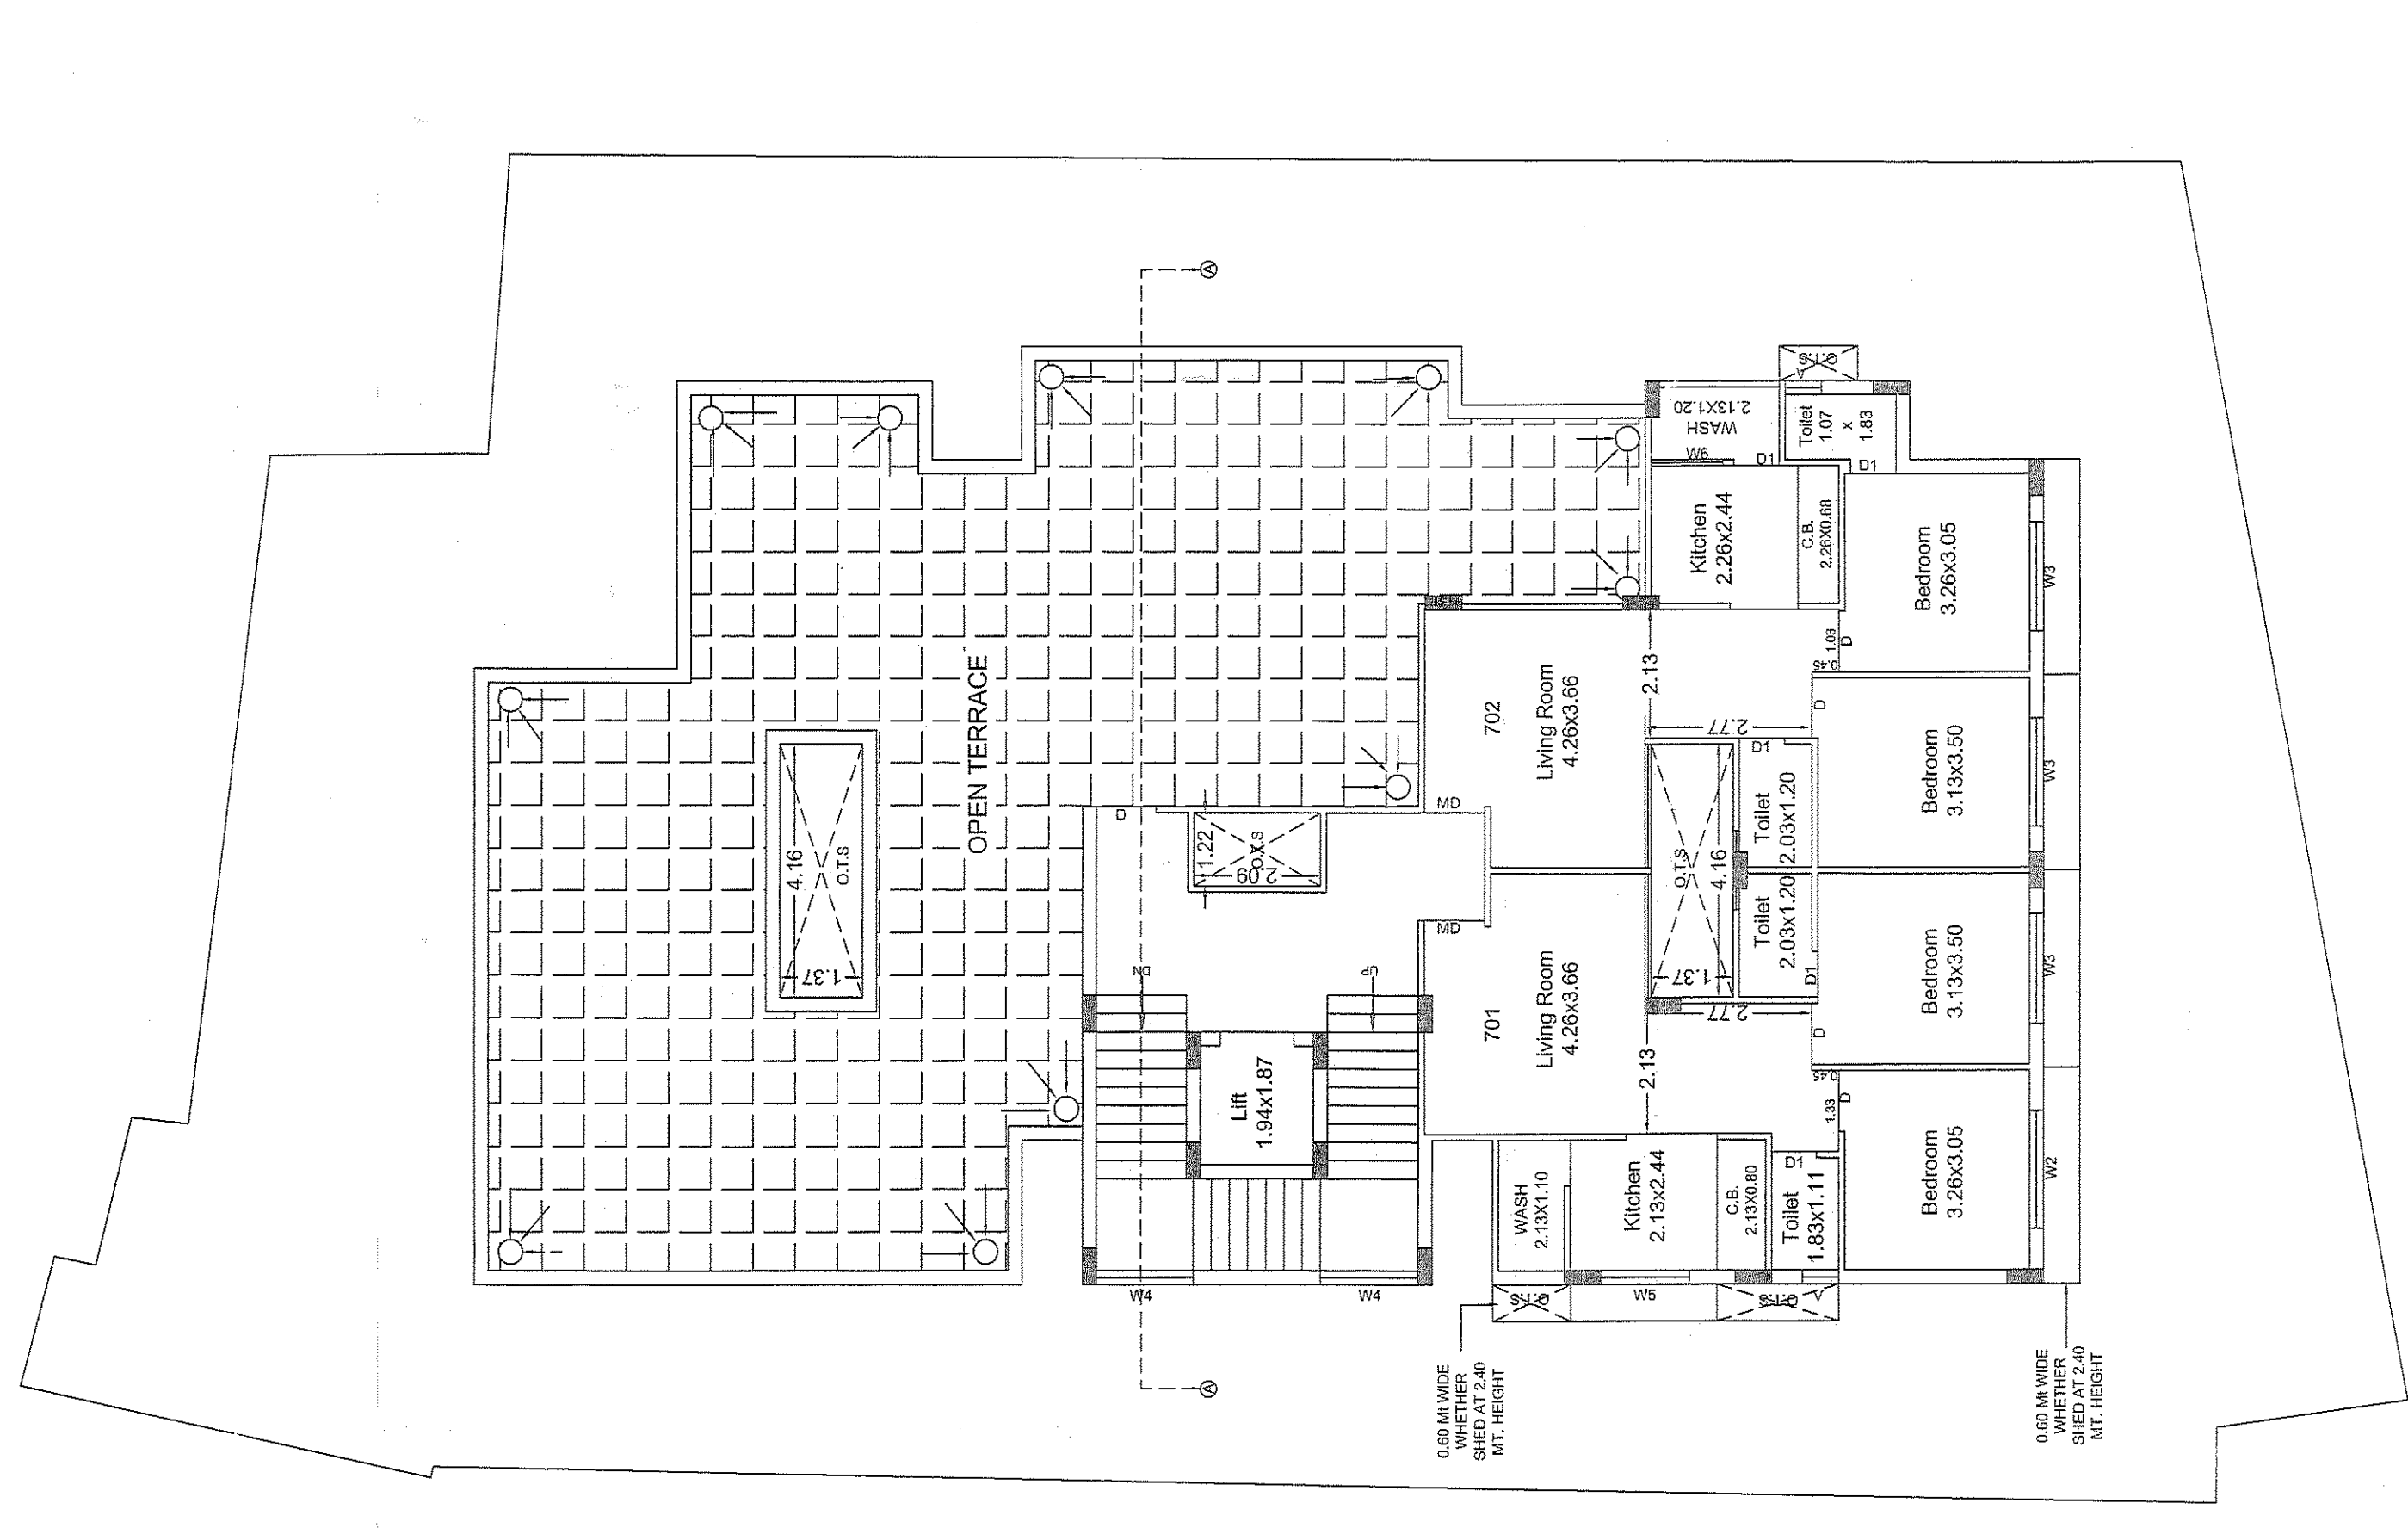
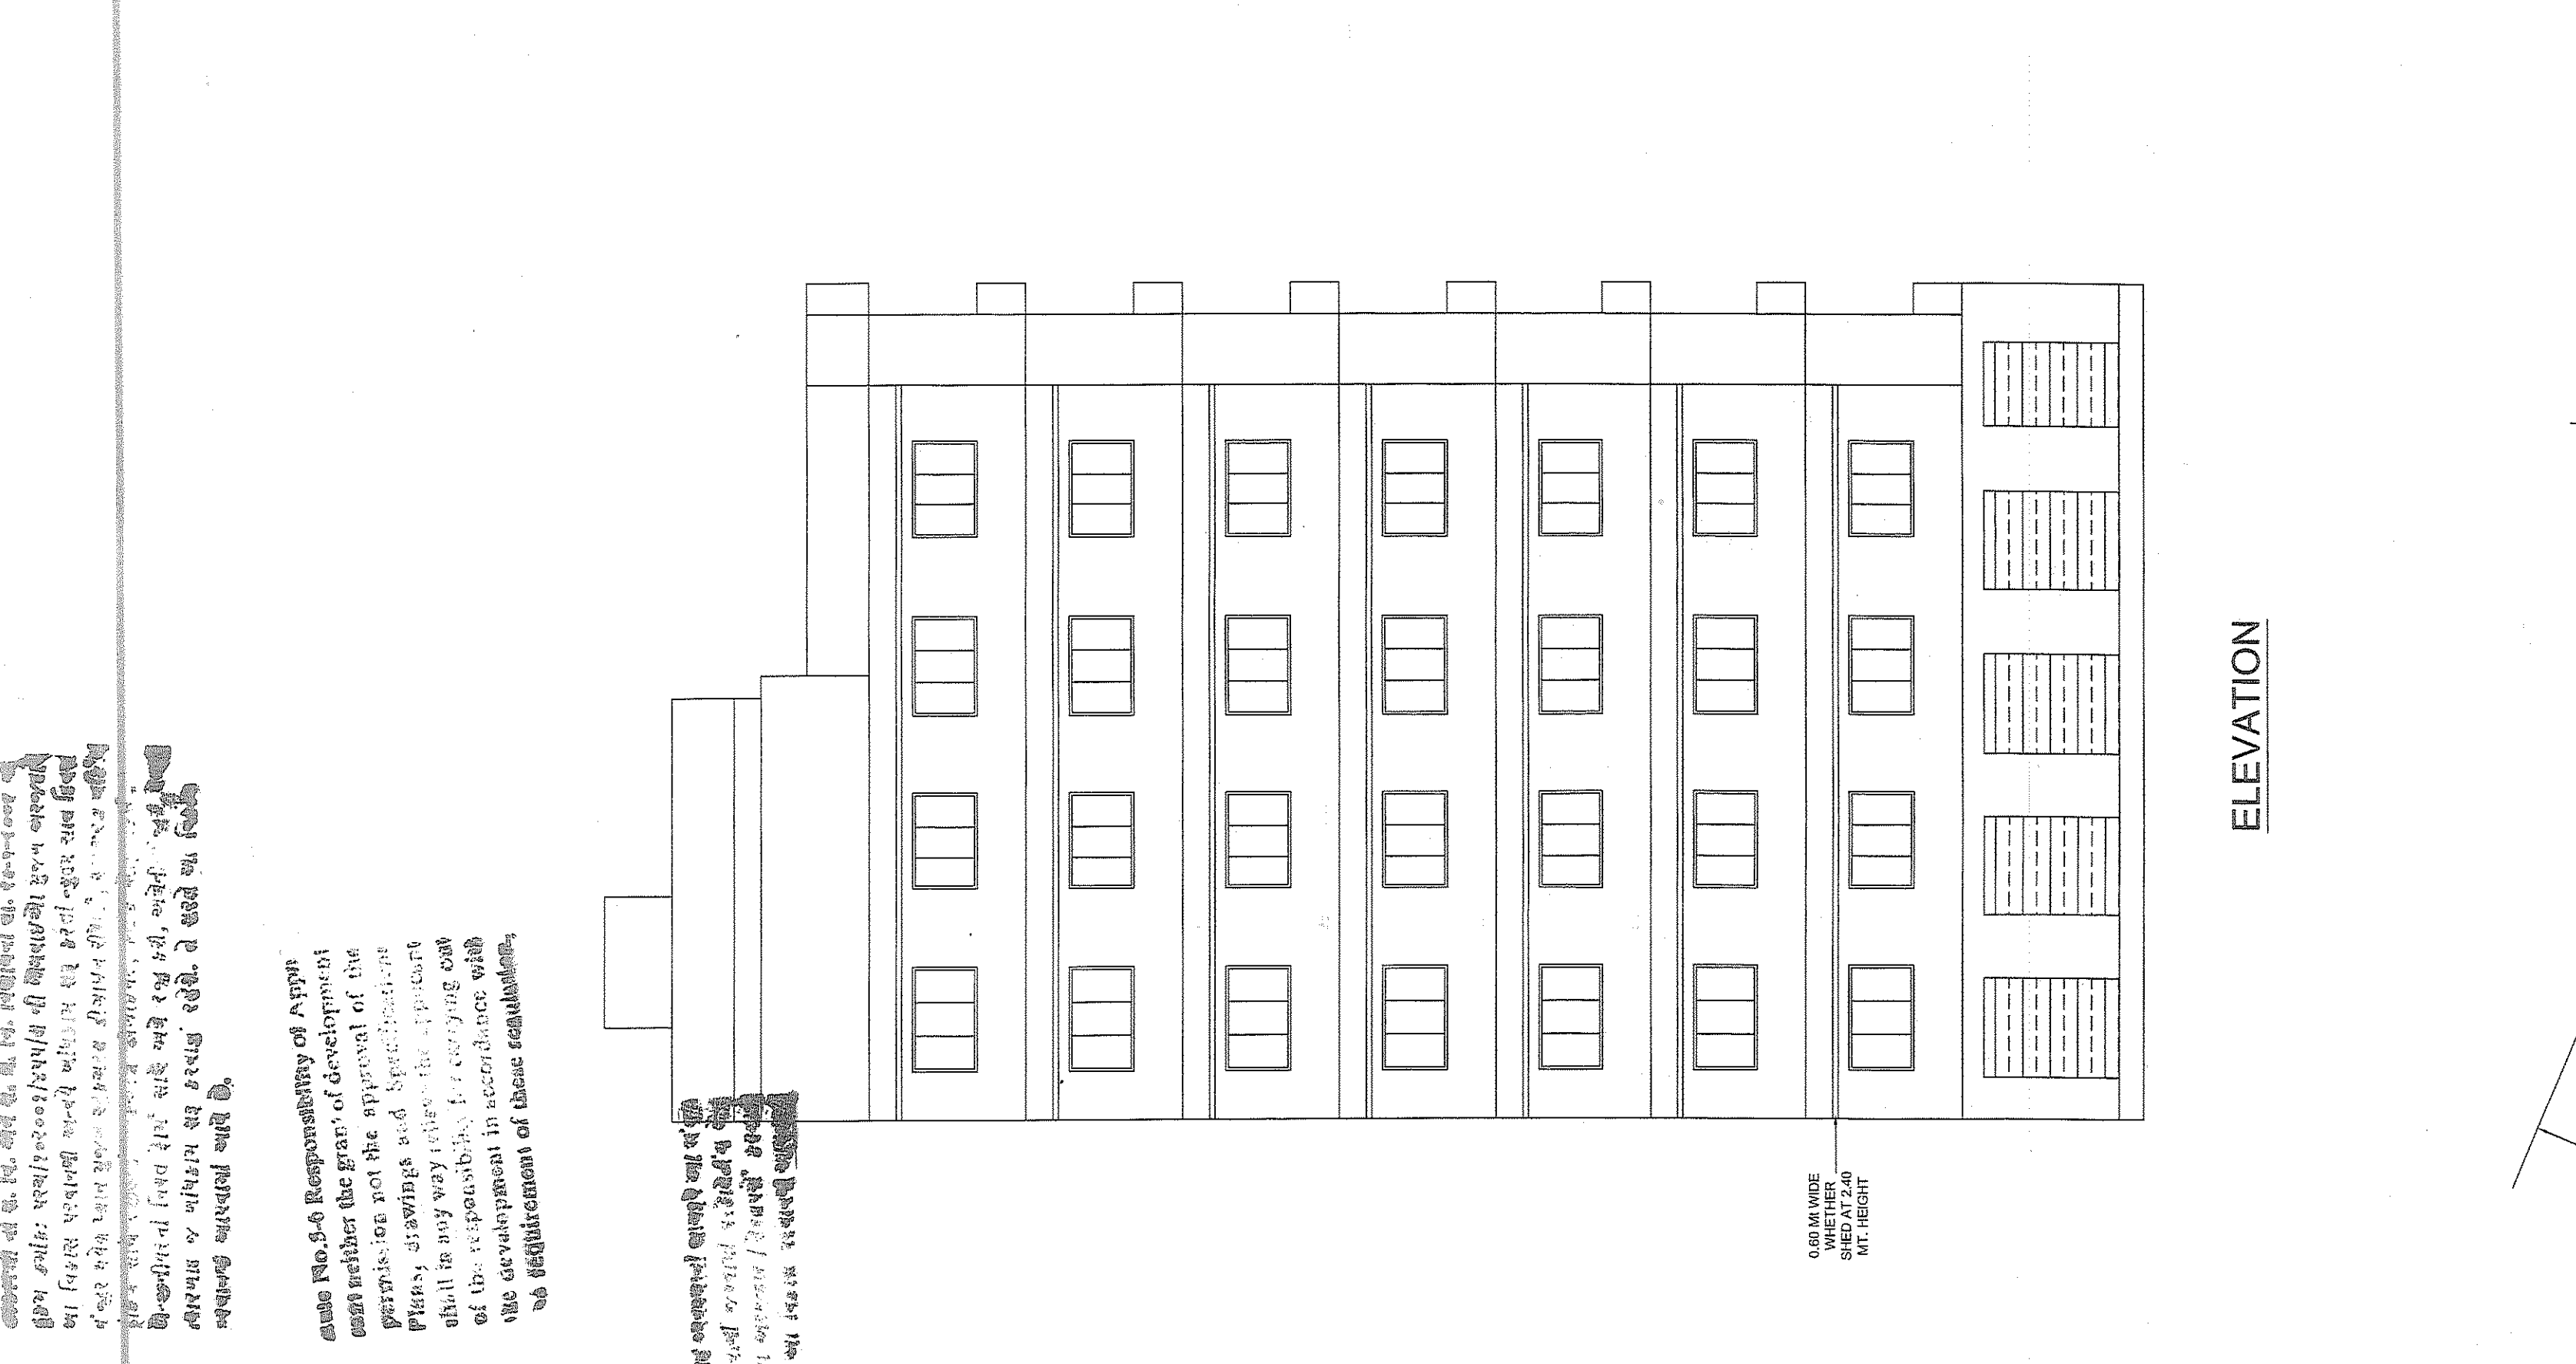
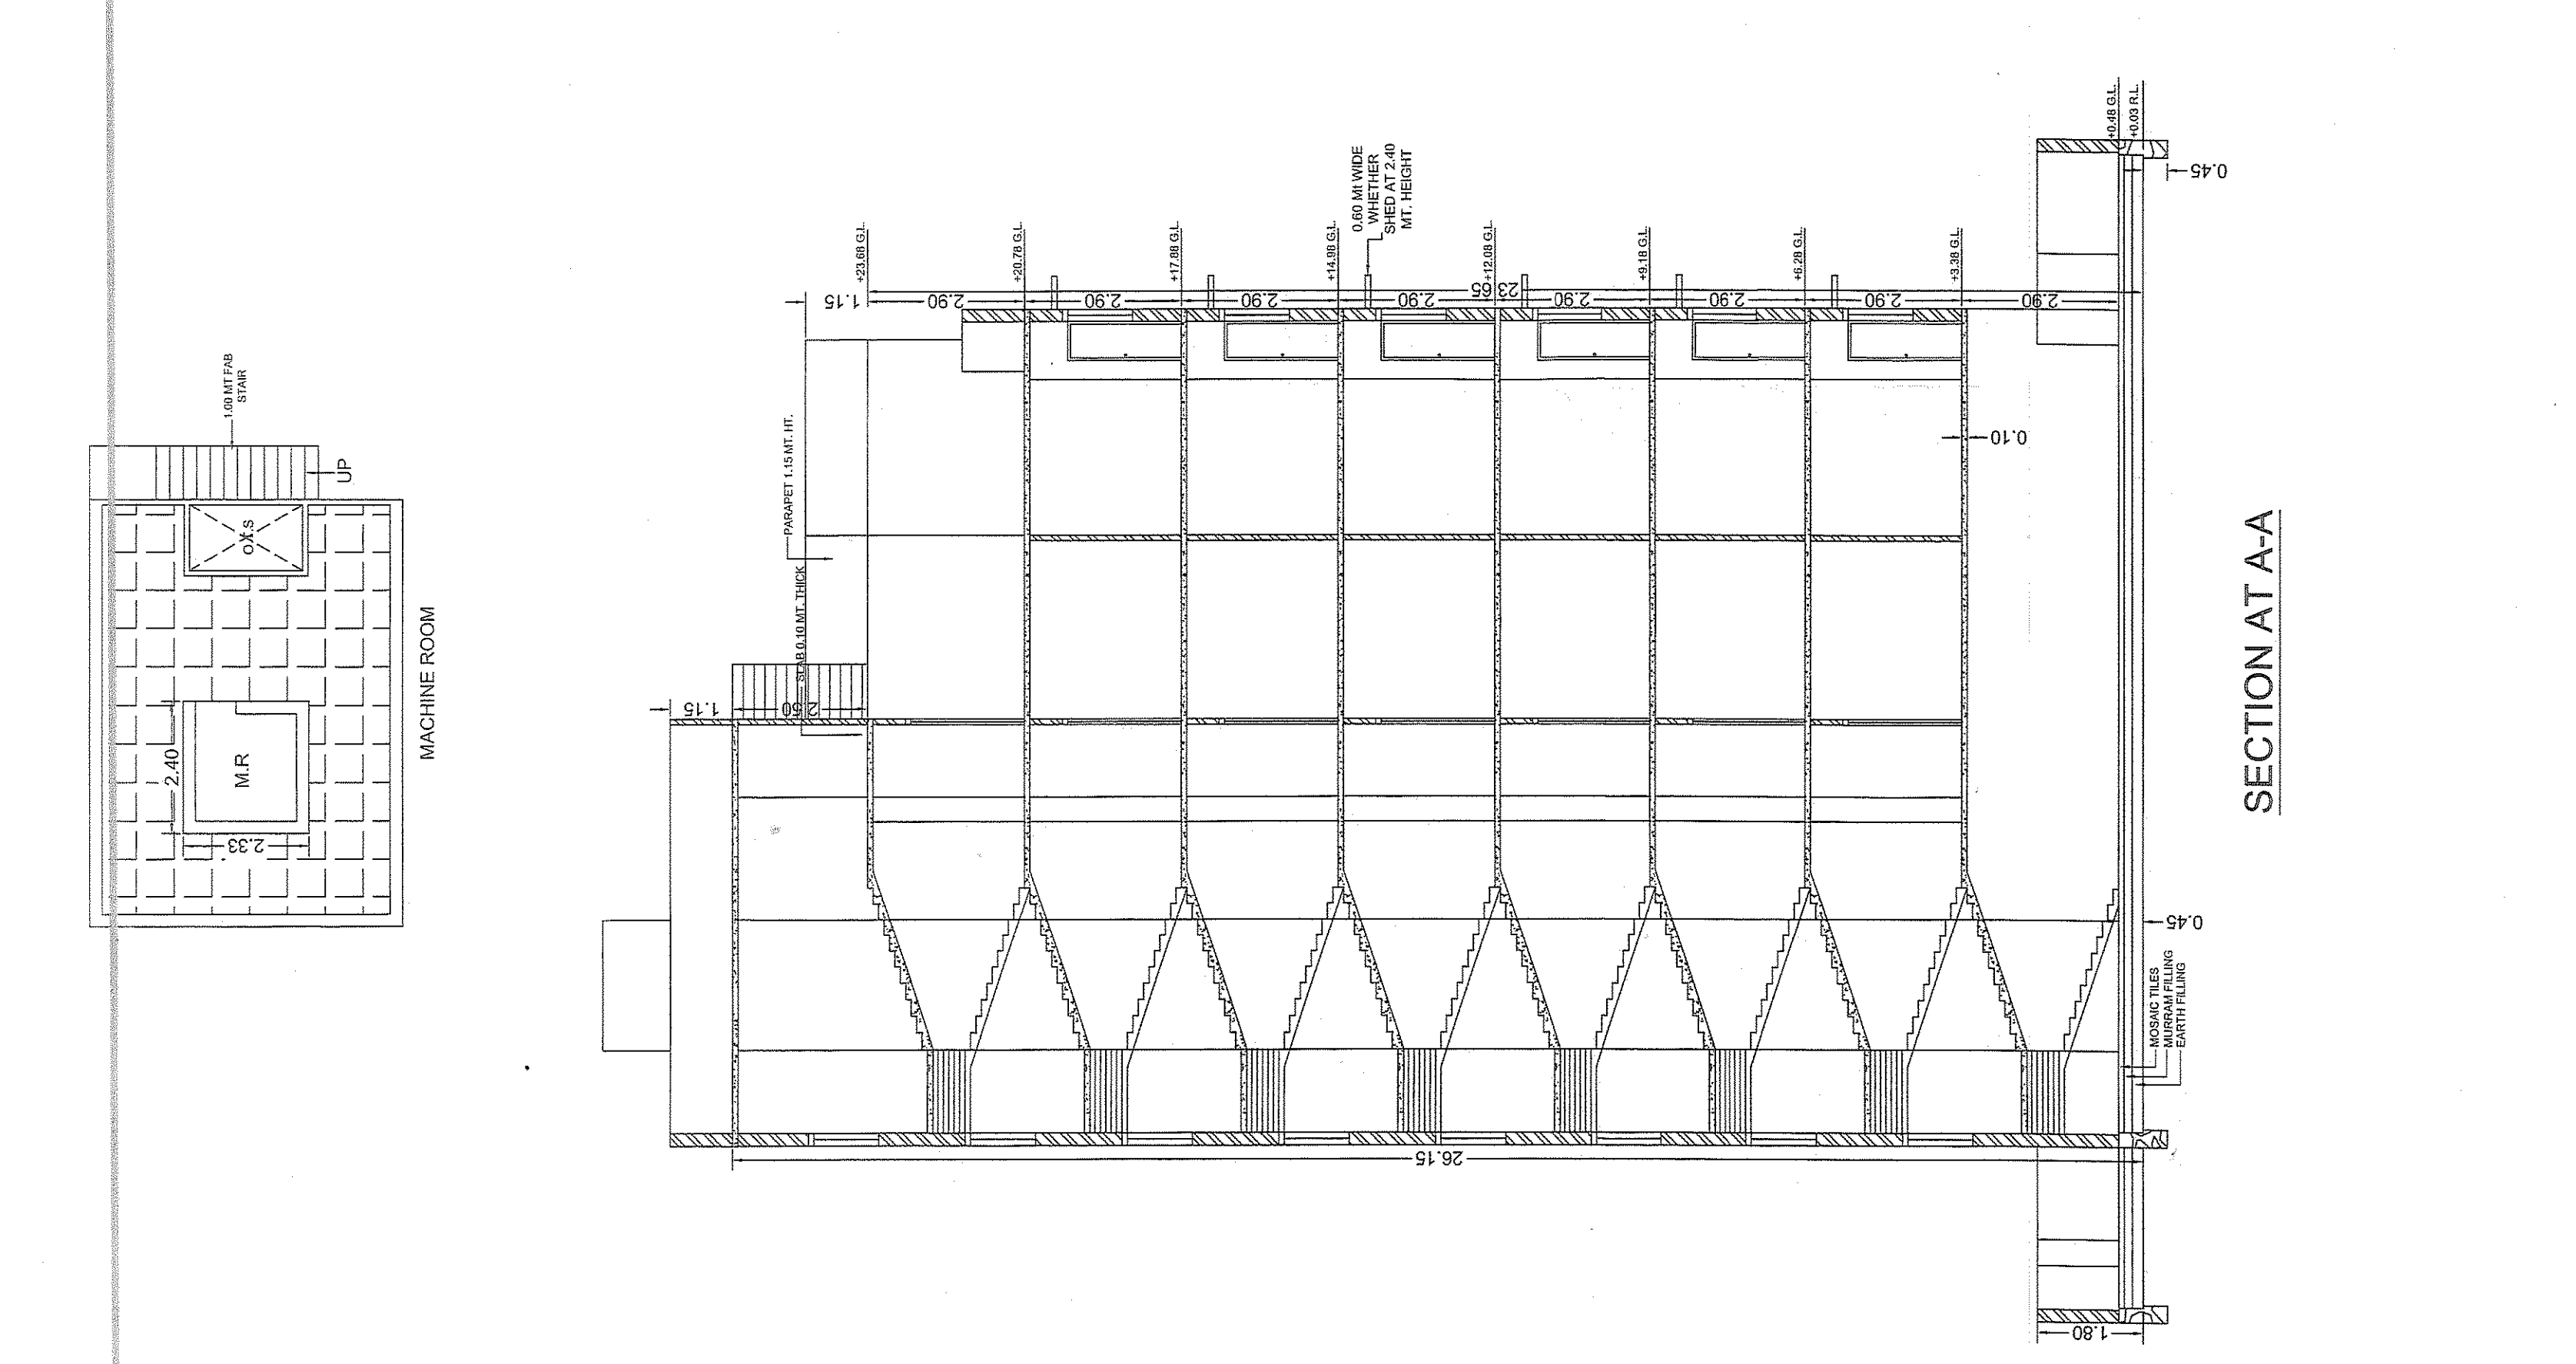
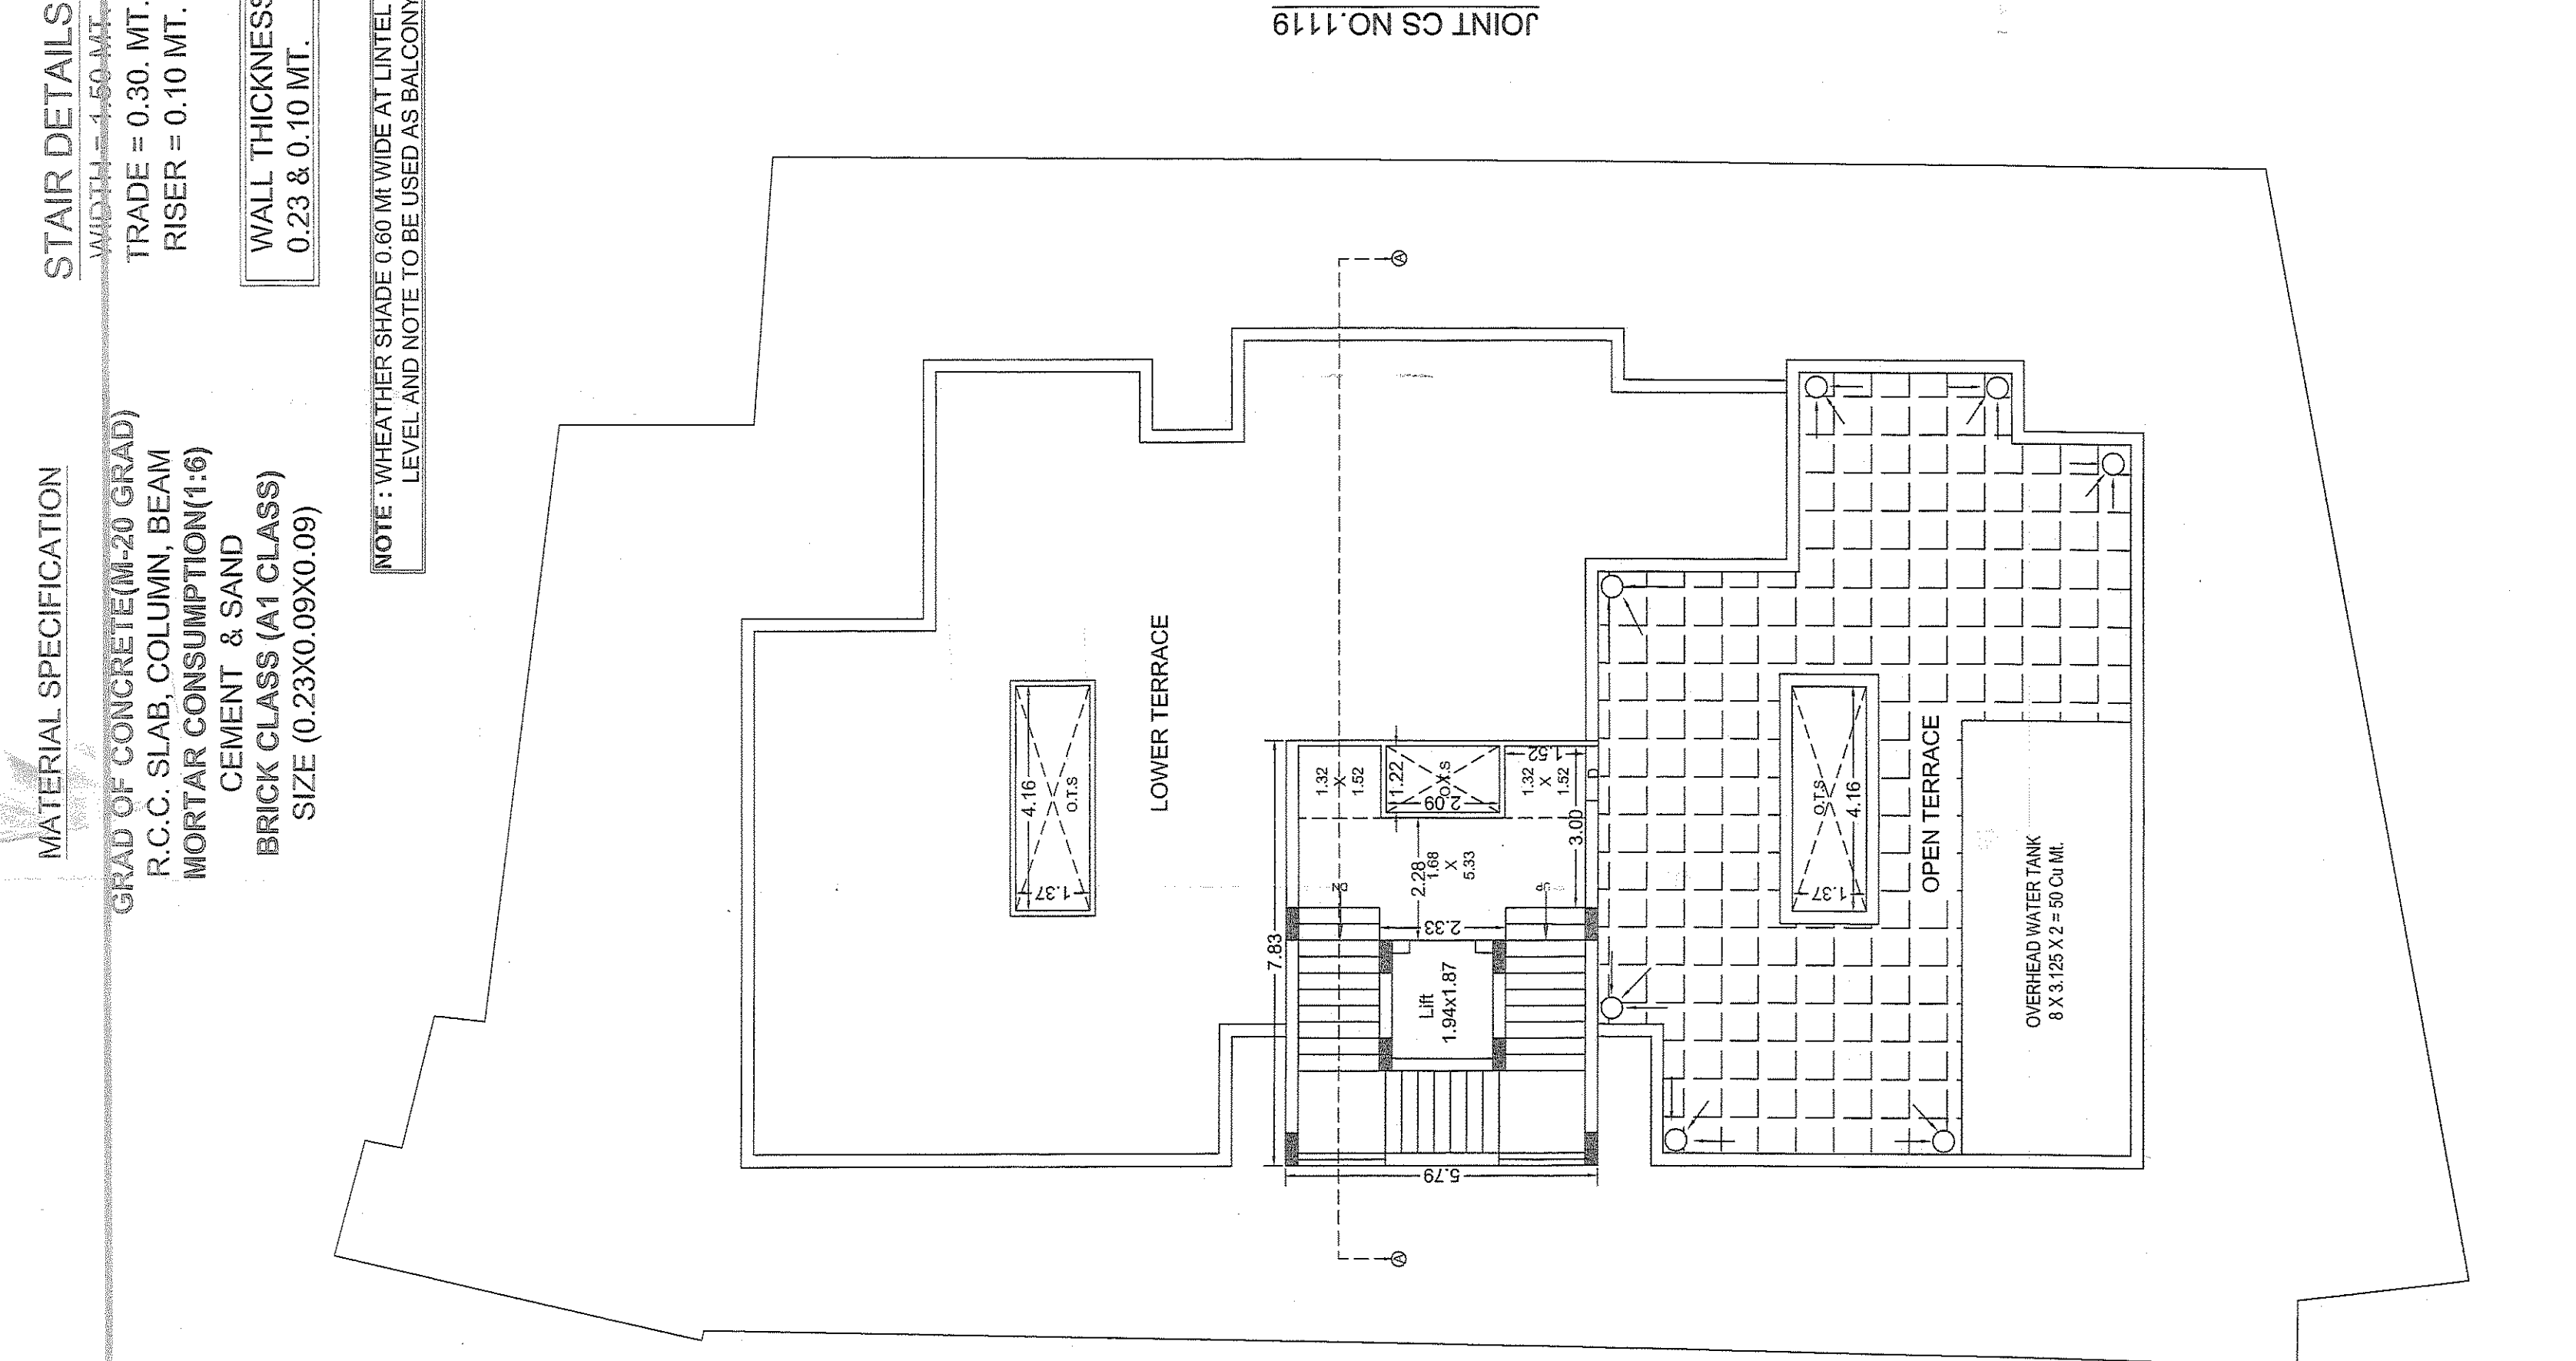
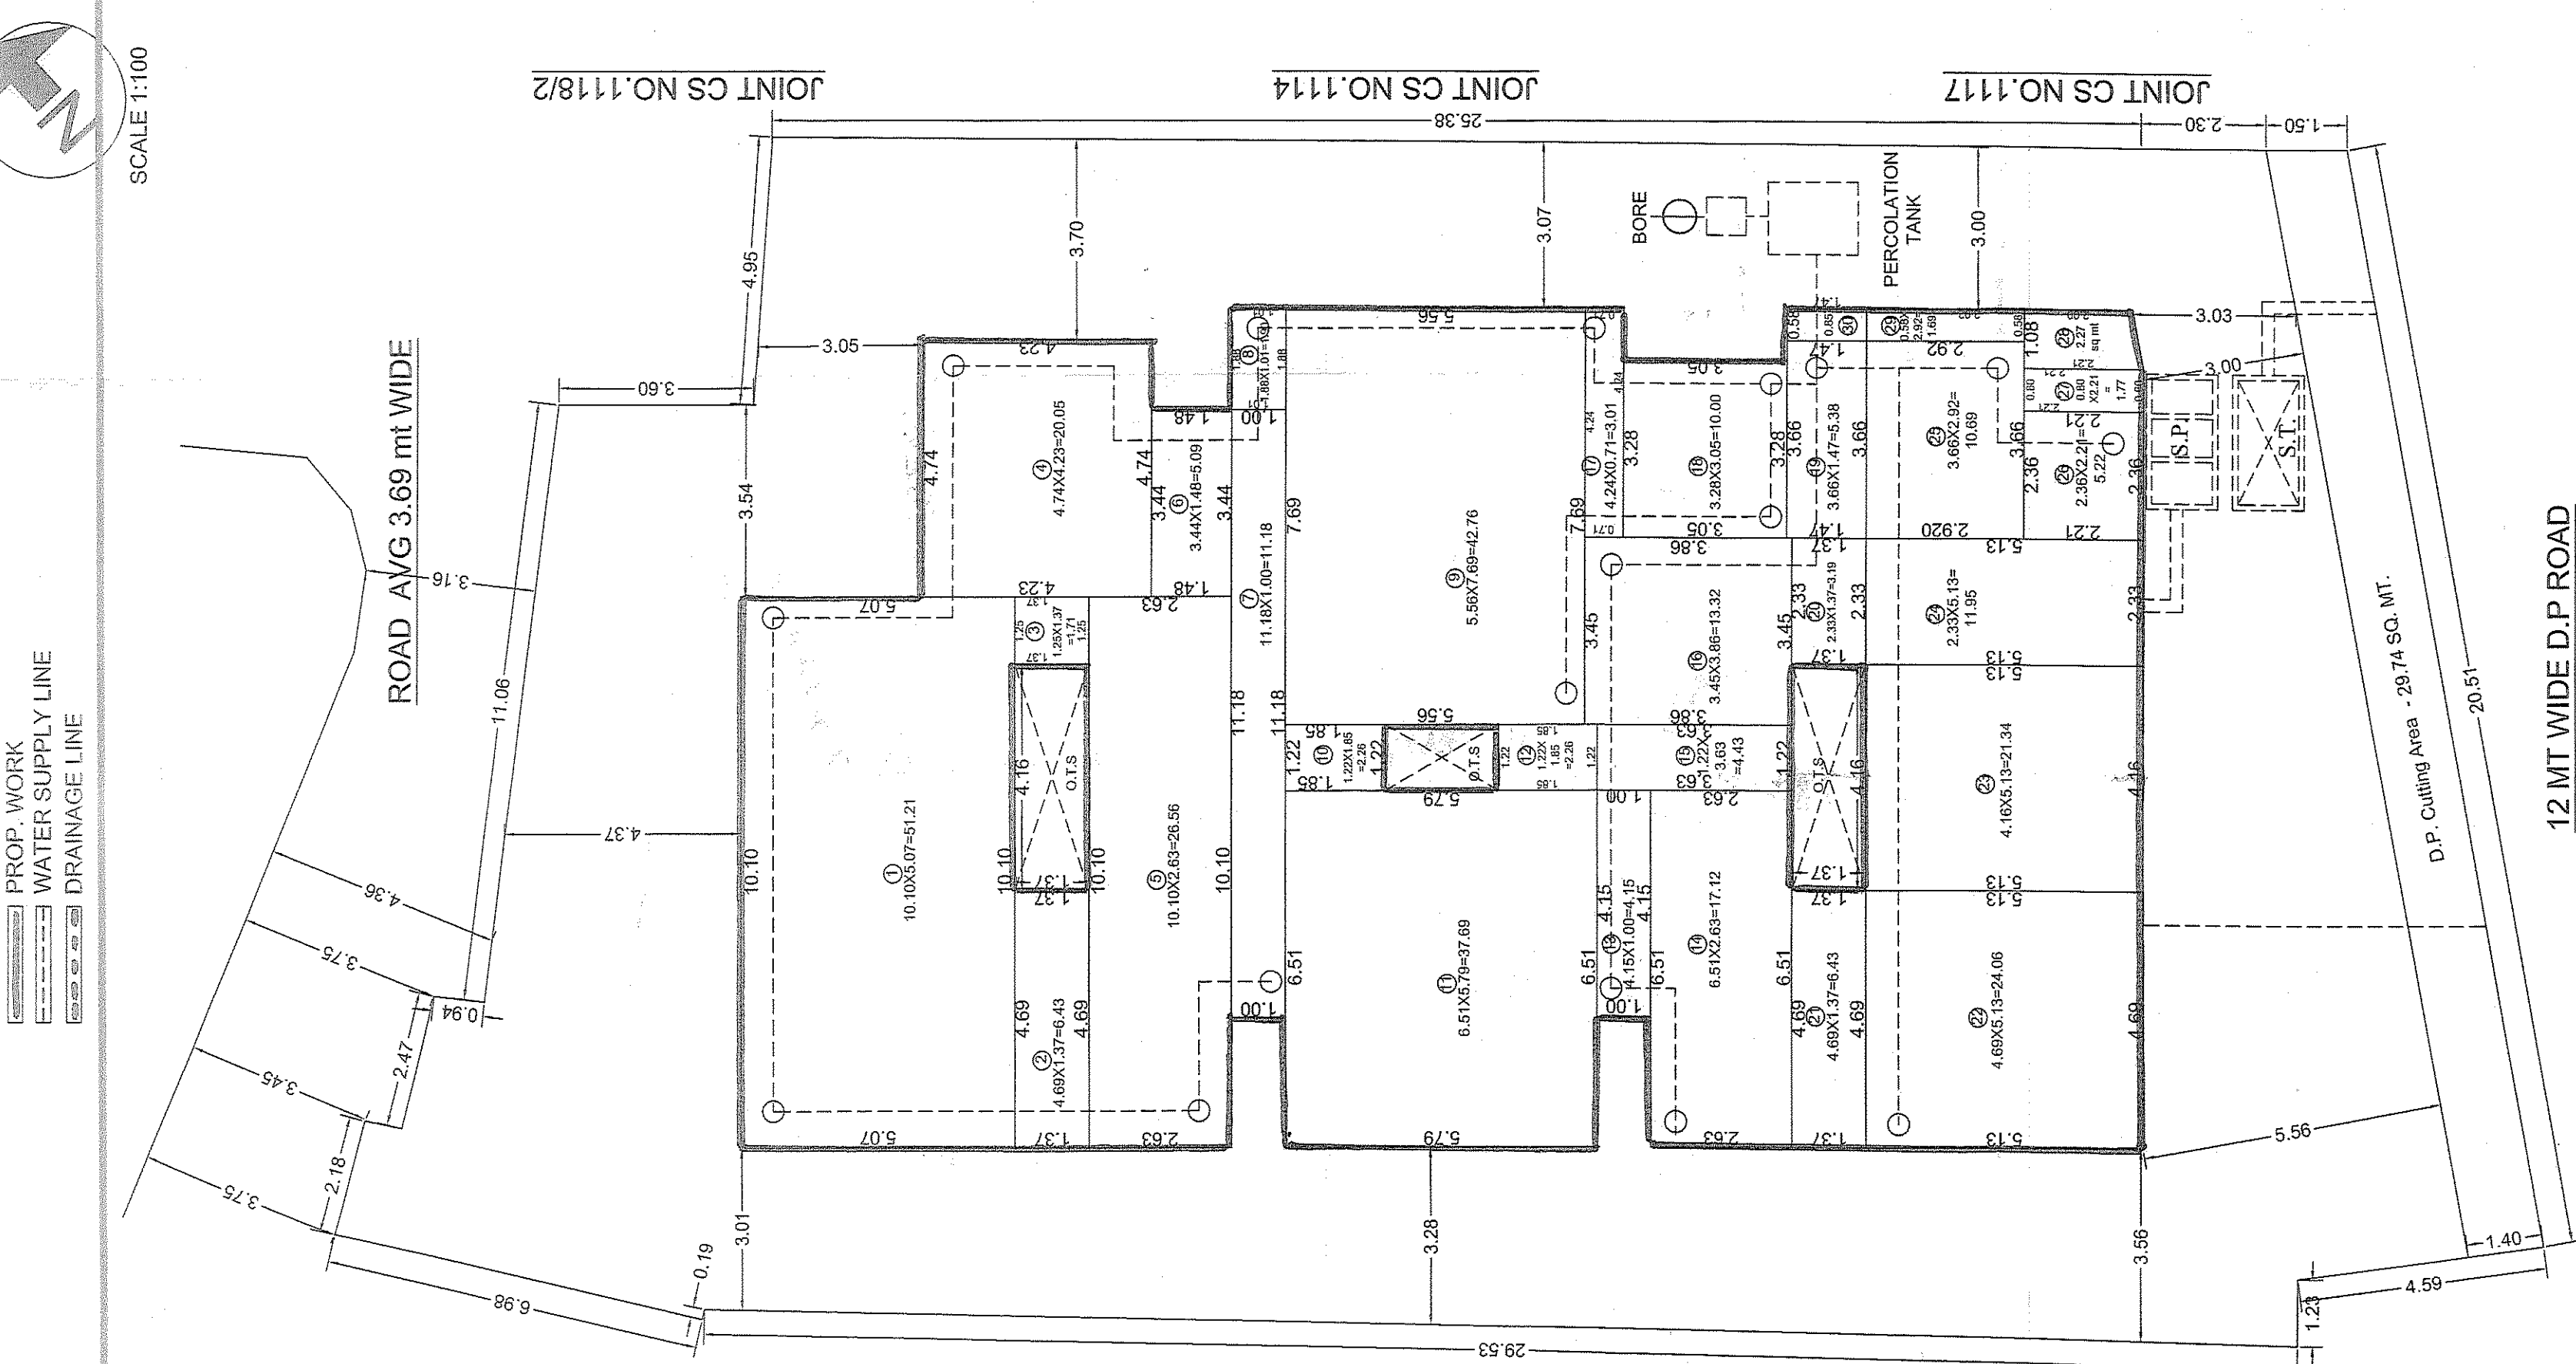


PLAN SHOWING PROP. DWELLING-3 (R-1) AND
MERCANTILE-1 WORK ON MAIN PART 'H' SHEET
NO. 2, S.NO. 7 NEW CS NO. 1118/1, ARYA SAMAJ
ROAD, NEAR KHAMBHALIYA GATE, JAMNAGAR.

SCHEDULE OF DOOR & WINDOW			
RS	1.83 X 2.50	W2	1.93 X 1.20
MD	1.00 X 2.10	W3	1.80 X 1.20
D	1.00 X 2.10	W4	1.62 X 1.20
D1	0.75 X 2.10	W5	1.52 X 1.20
W	2.09 X 1.20	W6	1.22 X 1.20
W1	2.03 X 1.20	V	0.60 X 0.60

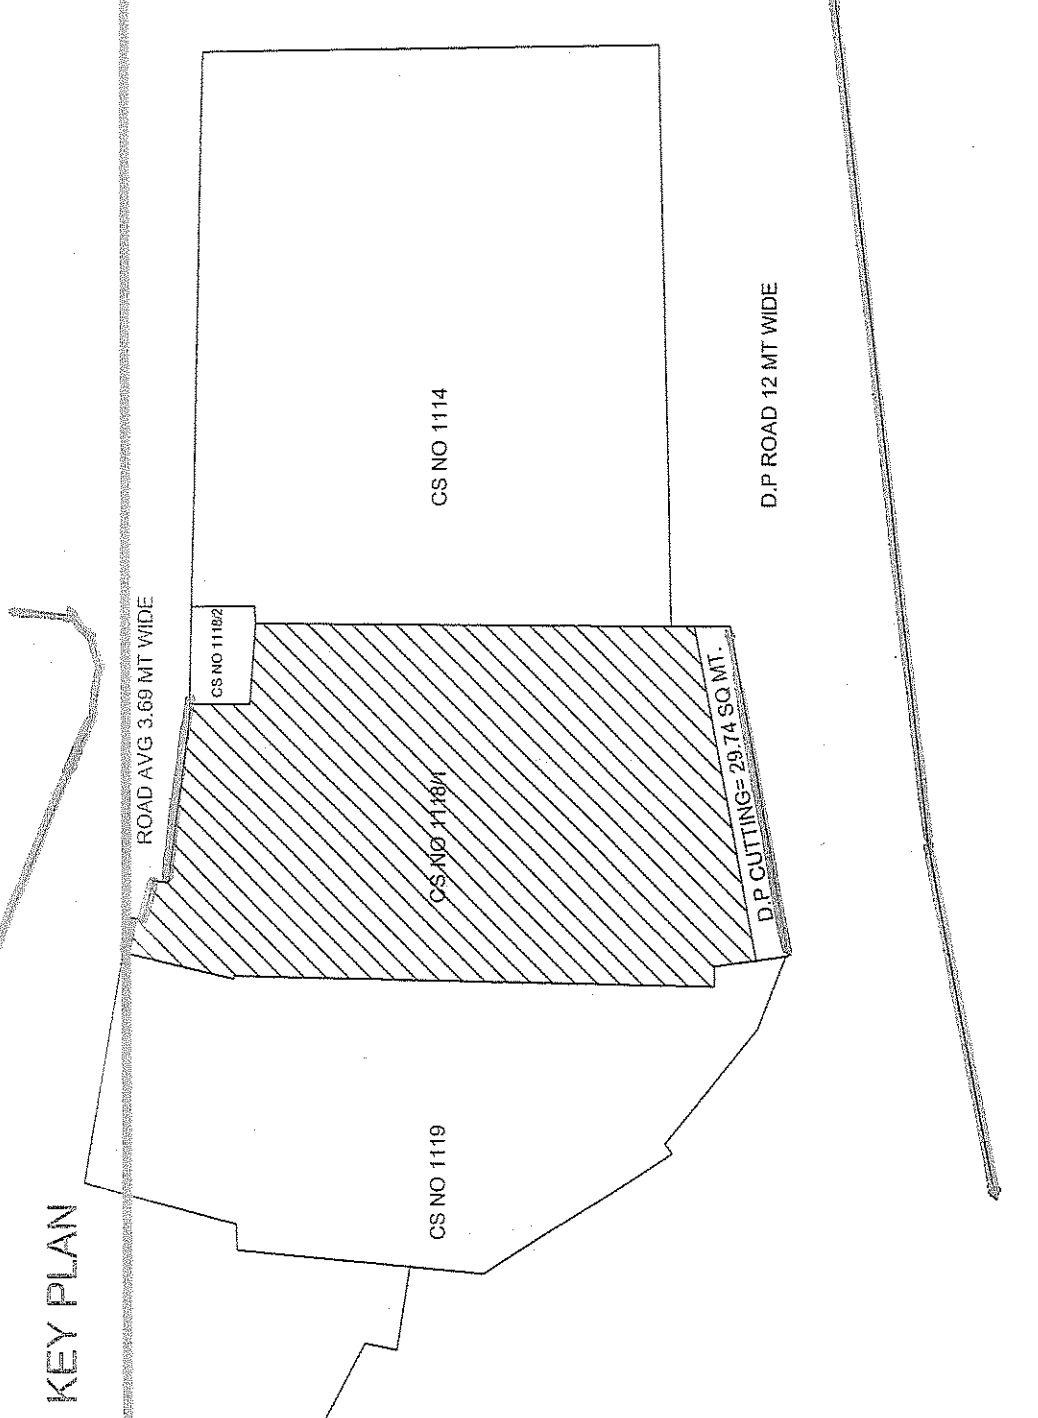

OWNER: CHAMANLAL MANEKCHAND SHAH

 
OWNER'S SIGN _____

[illegible]

AUTHORITY SHEET NO 1

[illegible]

PLAN SHOWING PROP. PARKING LAYOUT
ON MAIN PART 'H' SHEET NO. 2, S.NO.
7, NEW CS NO - 1118/1, ARYA SAMAJ
SCHOOL ROAD, OUTSIDE KHAMBHALIYA
GATE, JAMNAGAR.



JOINT CS NO.1118/2

JOINT CS NO 1114
COMMISSION OF THE EUROPEAN COMMUNITIES

OWNER: CHAMANLAL MANEKCHAND SHAH

OWNER'S SIGN *X C. M. Sholtz*

ENGINEER



 નાચન ઇજનર
 ટાઉન પ્લાનીંગ શાખા
 જામનગર મહાનગરપાલિકા


 સૌદી એન્જનીયર
 ટાઉન પ્લાનીંગ શાખા
 જામનગર મહાનગરપાલિકા

કા. નં. 2148119 ની રેકર્ડ નંબર, આપેલ છે.

AUTHORITY

SHEET NO 2

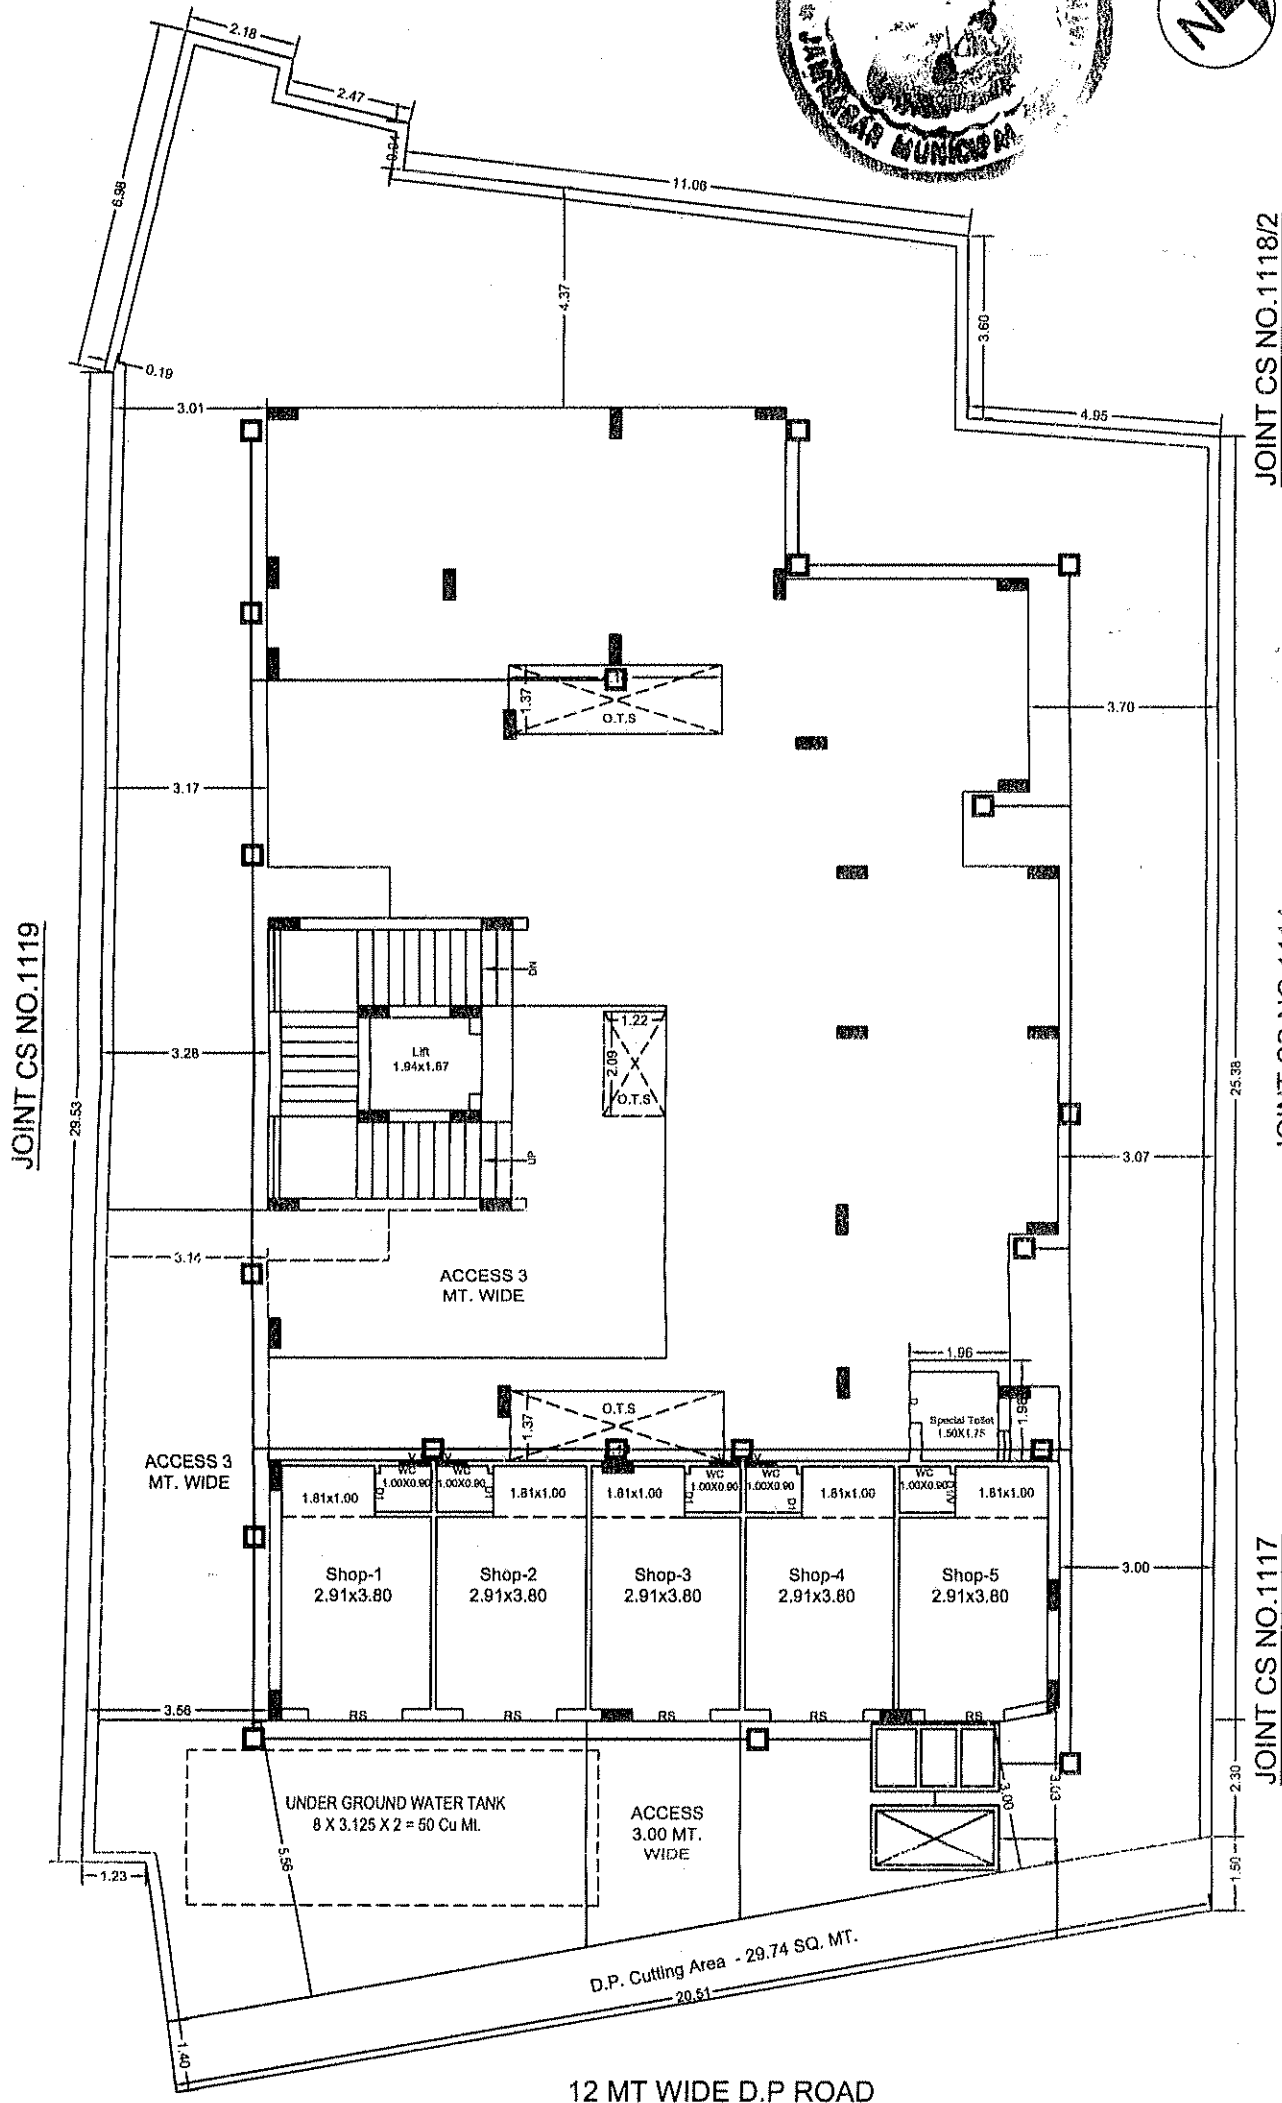

DRAINAGE LAYOUT

PLAN SHOWING DRAINAGE LAYOUT ON
MAIN PART 'H' SHEET NO. 2, S.NO. 7,
NEW CS NO - 1118/1, ARYA SAMAJ ROAD,
NEAR KHAMBHALIYA GATE, JAMNAGAR.

OWNER: CHAMANLAL MANEKCHAND SHAH

OWNER SIGN:

ANIL V. DATTANI
B.E. CIVIL
"GOKUL"
Opp. Galaxy Cinema
Jamnagar - 361001
LIC No. JMC/E-1/2003
JMC /S-1/2003

ENGINEER :

જામનગર મહાનગરપાલિકા

જામનગર મહાનગરપાલિકા

જામનગર મહાનગરપાલિકા

જામનગર મહાનગરપાલિકા

જામનગર મહાનગરપાલિકા

જામનગર મહાનગરપાલિકા

જામનગર મહાનગરપાલિકા

AUTHORITY:

SHEET NO 3