


AREA STATMENT	SQ.MT.
PLOT AREA AS / RECORD	= 6672.00 SQ. MT.
PLOT AREA AS/ SITE	= 6672.00 SQ. MT.
NET PLOT AREA	= 6672.00 SQ. MT.
REQD C.O. P. (10 % OF 6772.00)	= 667.20 SQ. MT.
PROP. C.O.P.	= 667.71 SQ. MT.
BALANCE PLOT AREA	= 6004.29 SQ. MT.
PROP. BUILT UP AREA @ GR.FL.	= 2021.70 SQ.MT
SUPER IMPOSED BUILT UP AREA	= 2047.86 SQ.MT
PERMI. F. S. I. (3.60) (6672.00 X 3.60)	= 24019.20 SQ. MT.
PROP. F.S.I	= 23322.29 SQ.MT.
F. S. I. CONSUMED	= 3.44

FLOOR	BLDG : A	BLDG : B	BLDG : C	BLDG : D	BLDG : E	TOTAL
BASEMENT FL.	-----	-----	-----	-----	-----	4741.50
GR FL./PARK.	476.16	443.50	443.50	329.27	329.27	2021.70
1st FLOOR	450.59	415.57	415.57	311.40	311.40	1904.53
2nd FLOOR	481.62	448.54	448.54	334.58	334.58	2047.86
3rd FLOOR	450.59	415.57	415.57	311.40	311.40	1904.53
4th FLOOR	450.59	415.57	415.57	311.40	311.40	1904.53
5th FLOOR	450.59	415.57	415.57	311.40	311.40	1904.53
6th FLOOR	450.59	415.57	415.57	311.40	311.40	1904.53
7th FLOOR	450.59	415.57	415.57	311.40	311.40	1904.53
8th FLOOR	450.59	415.57	415.57	311.40	311.40	1904.53
9th FLOOR	450.59	415.57	415.57	311.40	311.40	1904.53
10th FLOOR	450.59	415.57	415.57	311.40	311.40	1904.53
11th FLOOR	450.59	415.57	415.57	311.40	311.40	1904.53
12th FLOOR	450.59	415.57	415.57	311.40	311.40	1904.53
13th FLOOR	450.59	415.57	415.57	311.40	311.40	1904.53
14th FLOOR	450.59	415.57	415.57	311.40	311.40	1904.53
STAIR & LIFT M/C	51.29	55.82	55.82	49.97	49.97	262.87
TOTAL	6866.74	6350.27	6350.27	4762.02	4762.02	33802.82


FLOOR	BLDG : A	BLDG : B	BLDG : C	BLDG : D	BLDG : E	TOTAL
BASEMENT FL.	-----	-----	-----	-----	-----	-----
GR FL./PARK.	27.03	29.80	29.80	19.25	19.25	125.13
1st FLOOR	402.34	362.80	362.80	264.50	264.50	1656.94
2nd FLOOR	402.34	362.80	362.80	264.50	264.50	1656.94
3rd FLOOR	402.34	362.80	362.80	264.50	264.50	1656.94
4th FLOOR	402.34	362.80	362.80	264.50	264.50	1656.94
5th FLOOR	402.34	362.80	362.80	264.50	264.50	1656.94
6th FLOOR	402.34	362.80	362.80	264.50	264.50	1656.94
7th FLOOR	402.34	362.80	362.80	264.50	264.50	1656.94
8th FLOOR	402.34	362.80	362.80	264.50	264.50	1656.94
9th FLOOR	402.34	362.80	362.80	264.50	264.50	1656.94
10th FLOOR	402.34	362.80	362.80	264.50	264.50	1656.94
11th FLOOR	402.34	362.80	362.80	264.50	264.50	1656.94
12th FLOOR	402.34	362.80	362.80	264.50	264.50	1656.94
13th FLOOR	402.34	362.80	362.80	264.50	264.50	1656.94
14th FLOOR	402.34	362.80	362.80	264.50	264.50	1656.94
STAIR & LIFT M/C	00	00	00	00	00	0
TOTAL	5659.79	5109.00	5109.00	3722.25	3722.25	23322.29

Development permission is granted to the condition that it shall be the responsibility of the applicant and his Architect/Engineer/Surveyor/Structural designer, to follow the relevant I. S specification in structural design to ensure safety of the buildings and as such structural designs are not verified Unless renewed the validity of this Permission expires on Dt. 30.09.21-2024

Permission for sub-division/amaigamāpn development as Sanctioned by Commissioner under the provisions of the Gujarat Town Planning and Urban Development Act. 1976 and the Bombay provisional Municipal Corporation Act. 1949 is granted for the Land bearing C.-S. No./R.S. No./F.P. No. 111, 112, 113, 1666, 16

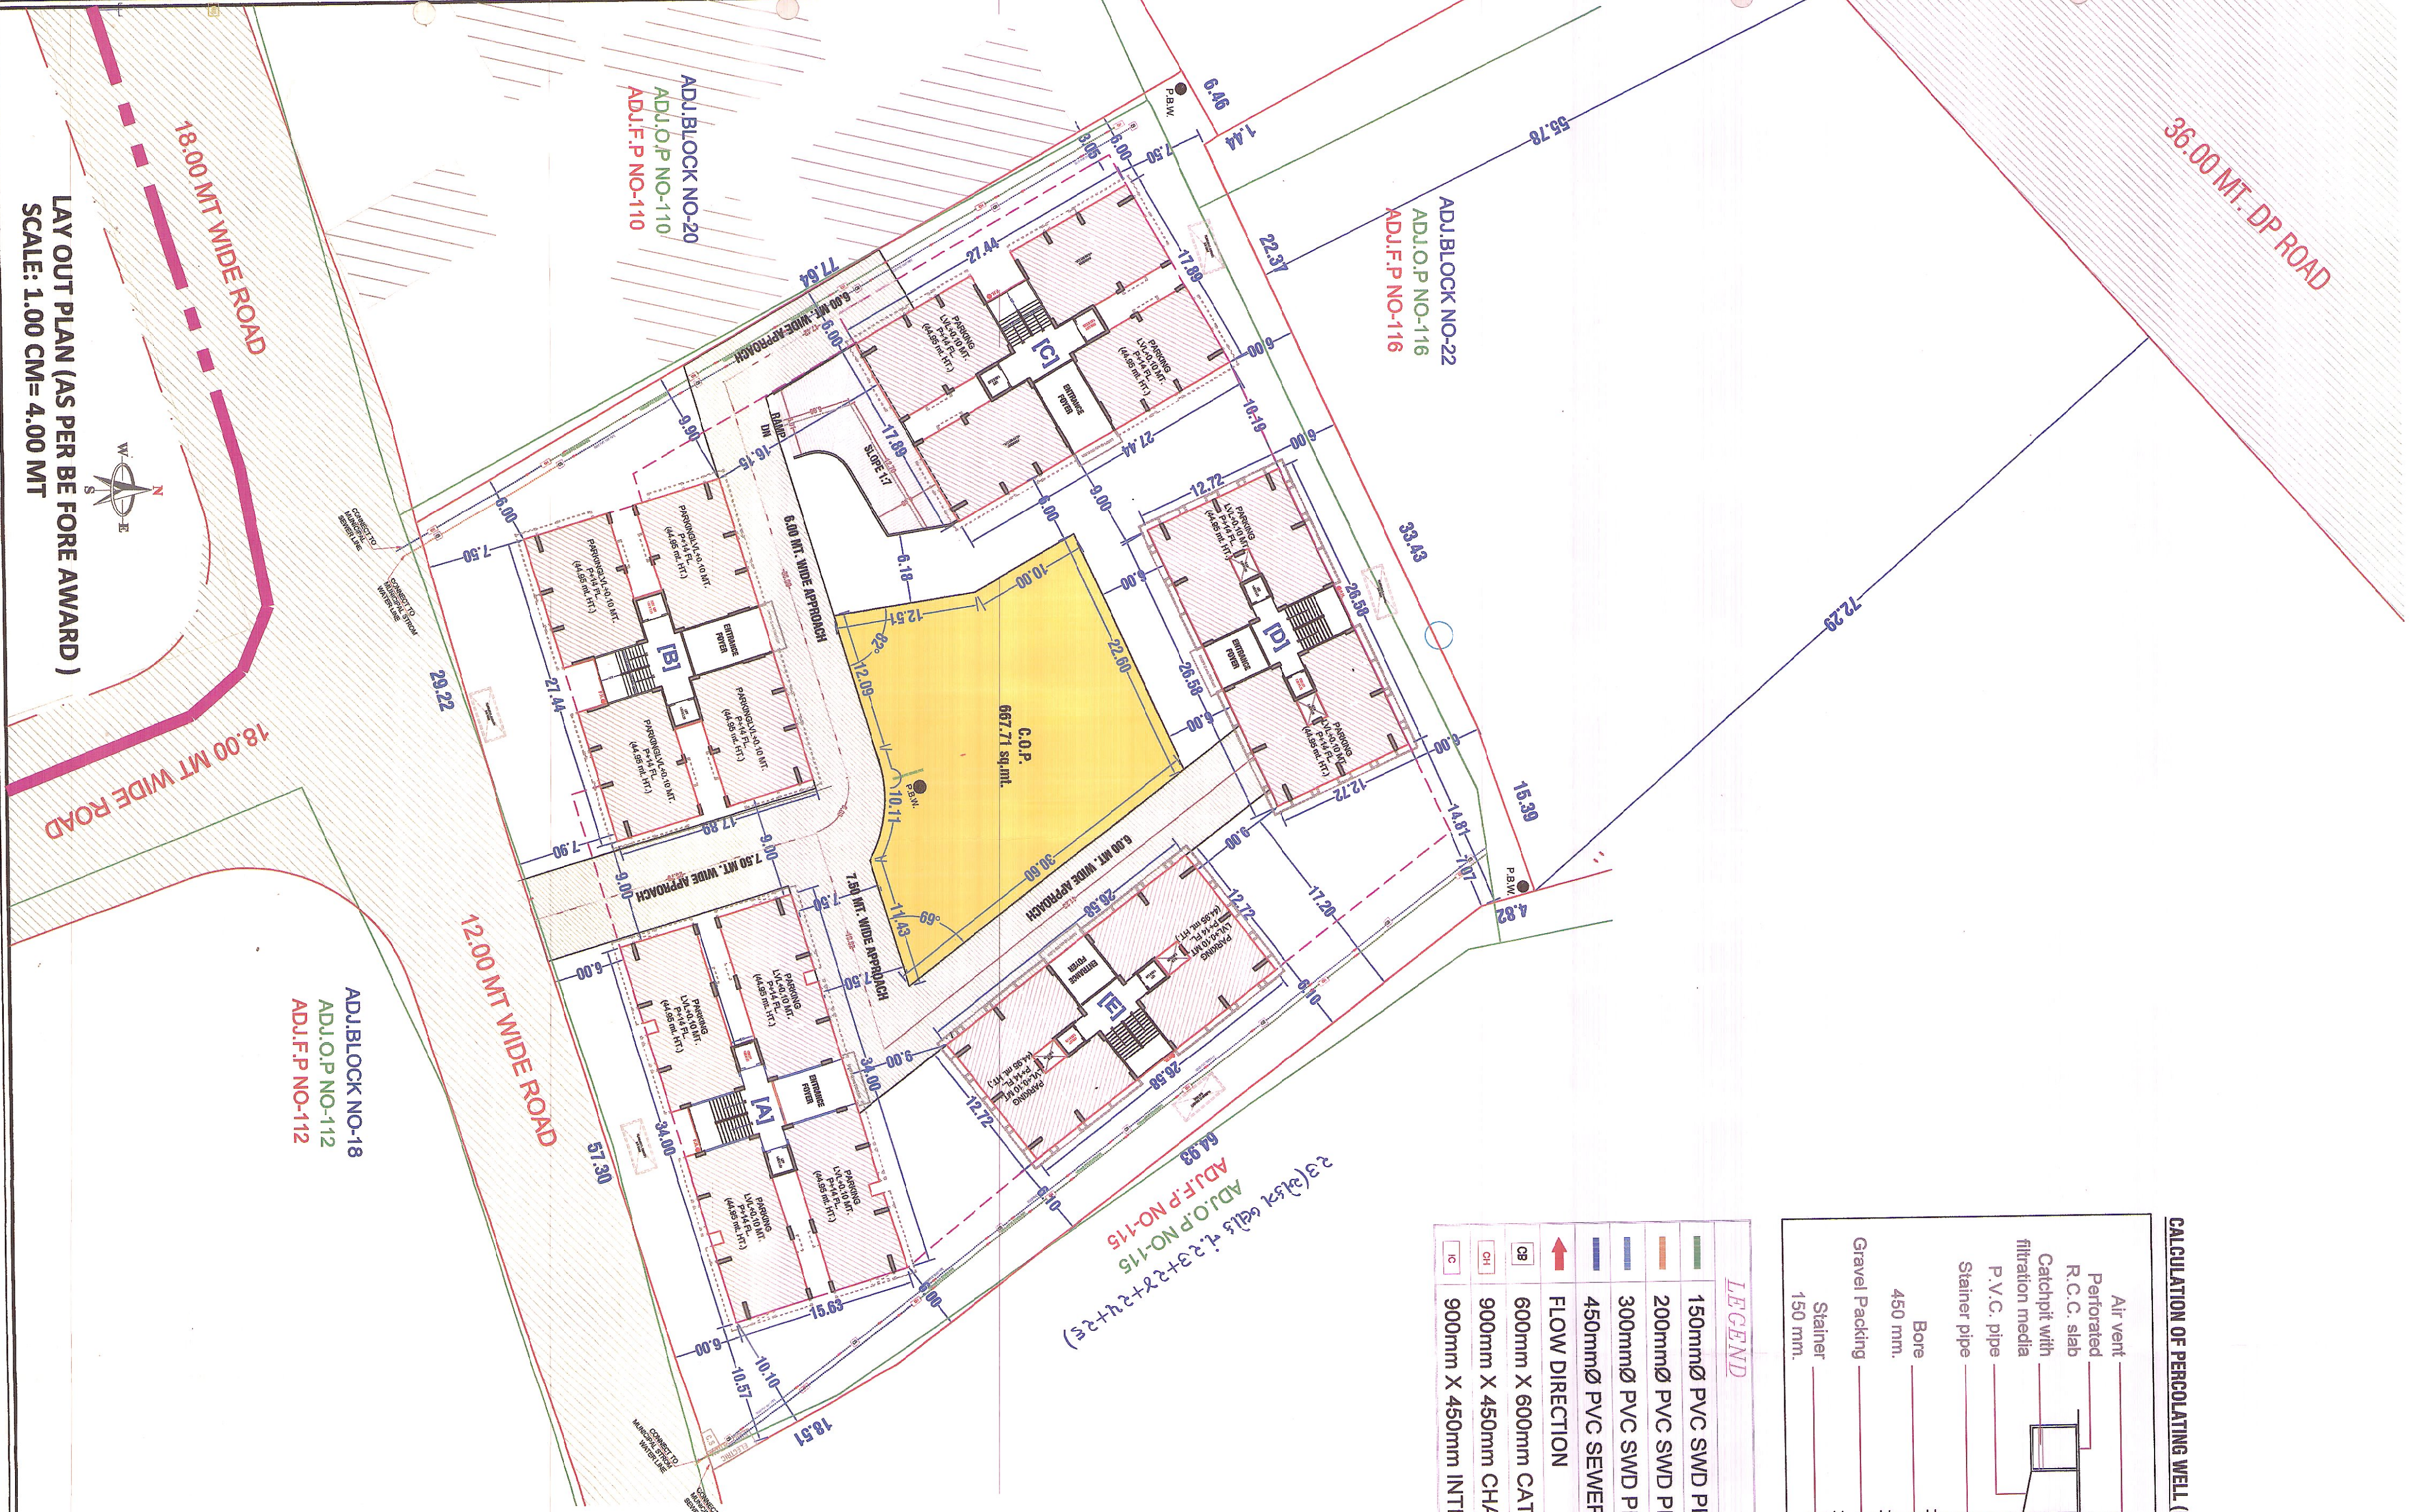

CALCULATION OF PERCOLATING WELL (P.B.W.)

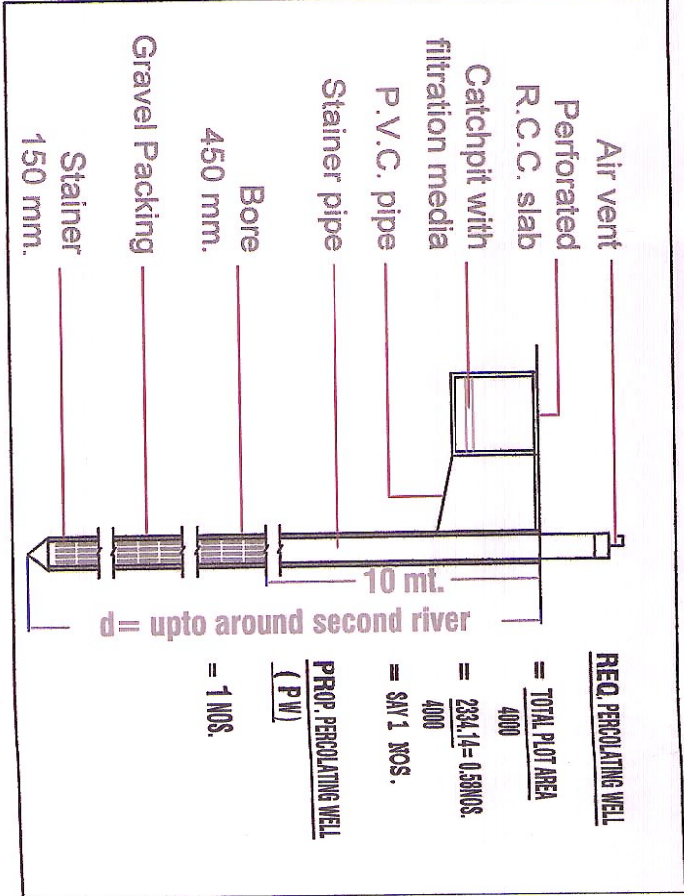

LEGEND	
	150mmØ PVC SWD PIPE
	200mmØ PVC SWD PIPE
	300mmØ PVC SWD PIPE
	450mmØ PVC SEWER PIPE
	FLOW DIRECTION
	600mm X 600mm CATCH BASIN
	900mm X 450mm CHAMBER (TP)
	900mm X 450mm INTERCEPTING CHAMBER (TP)

DRG. TITLE

DRAINAGE LAYOUT PLAN

OWNER SIGN

(x)

OWNER NAME

Gokul Corporation

ARCHITECT SIGN

JIGAR MAKANI

ARCHITECT NAME

Ar. Aditya Madhav

ENGINEER SIGN

(Signature)

ENGINEER NAME

Ar. Aditya Madhav

PROJECT ADDRESS

LIC No. : TD/EDR/1851
B-602, RUD Business Hub,
MT. Nagnanvali Soc., Vadgam,
Surat (Gujarat), India.

PROJECT ADDRESS

110/12A, Thapar Road, Vadgam,
Surat (Gujarat), India.
Ph. +91 79 700 7705
GOKUL CORP. INDIA